


**ADDENDUM NO. 1**

**DATE:** May 4, 2026

**PROJECT:** Special Education Alterations to  
Centennial High School  
Williamson County Schools  
J+B No. 2519  
WCS RFB #1408

**ARCHITECT:** Johnson + Bailey Architects, P.C.  
City Center, Suite 700  
100 East Vine Street  
Murfreesboro, TN. 37130

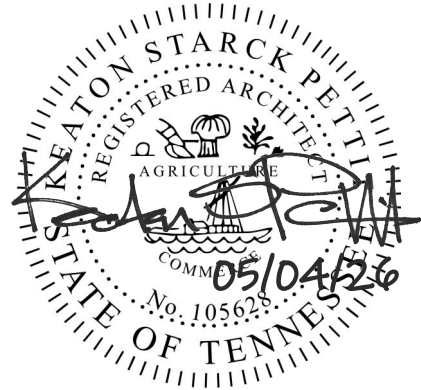

The following Addendum adds to, corrects, or supersedes Contract Documents dated March 10, 2026 and is as follows:

**CHANGES TO THE DRAWINGS**

---

**DRAWING A1.1**

**REFERENCE:** OVERALL FIRST FLOOR PLAN

**REVISE:** Location of new calm room scope as shown on the attached revised drawing A1.1 dated 05/04/26.

**DRAWING A1.2**

**REFERENCE:** LIFE SAFETY PLAN - FIRST FLOOR

**REVISE:** Location of new calm room scope as shown on the attached revised drawing A1.2 dated 05/04/26.

**DRAWING A2.1**

**REFERENCE:** DEMOLITION PLAN NOTES

**REVISE:** Demolition Plan Note 5 to read as shown on the attached revised drawing A2.1 dated 05/04/26.

**REFERENCE:** DEMOLITION REFLECTED CEILING PLAN - CLASSROOM D-11

**REVISE:** Location of new calm room demolition scope as shown on the attached revised drawing A2.1 dated 05/04/26.

**DRAWING A2.2**

**REFERENCE:** FLOOR PLAN NOTES

**REVISE:** Floor Plan Note 5 to read as shown on the attached revised drawing A2.2 dated 05/04/26.

**REFERENCE:** LARGE SCALE FLOOR PLAN

**REVISE:** Location of new calm room scope as shown on the attached revised drawing A2.2 dated 05/04/26.

ADDENDUM NO. 1  
Special Education Alterations to  
Centennial High School  
Williamson County Schools  
J+B No. 2519  
WCS RFB #1408  
May 4, 2026  
Page 2

**REFERENCE:** REFLECTED CEILING PLAN - NEW WORK - CLASSROOM D-11

REVISE: Location of new calm room scope as shown on the attached revised drawing A2.2 dated 05/04/26.

**DRAWING A9.1**

**REFERENCE:** TOILET ELEVATION NO. 9

ADD: Glazing Blackout Film Scope to Door of Tit. D-19 as shown on the attached revised drawing A9.1 dated 05/04/26.

**DRAWING A9.2**

**REFERENCE:** ENTIRE SHEET

ADD: New structural detail 1/A9.2 as shown on the attached revised drawing A9.2 dated 05/04/26.

**DRAWING M201**

**REFERENCE:** 1/M201 HVAC DEMO PLAN

REVISE: Location of calm room HVAC scope as shown on the attached revised drawing M201 dated 05/04/26.

**REFERENCE:** 3/M201 HVAC PLAN

REVISE: Location of calm room HVAC scope as shown on the attached revised drawing PFP201 dated 05/04/26.

**DRAWING PFP201**

**REFERENCE:** 6/PFP201 PLUMBING AND FIRE PROTECTION DEMO PLAN

REVISE: Location of calm room fire protection scope as shown on the attached revised drawing PFP201 dated 05/04/26.

**REFERENCE:** 2/PFP201 PLUMBING AND FIRE PROTECTION PLAN

REVISE: Location of calm room fire protection scope as shown on the attached revised drawing PFP201 dated 05/04/26.

**DRAWING E101**

**REFERENCE:** 1/E101 ELECTRICAL DEMO PLAN

REVISE: Location of calm room demolition scope as shown on the attached revised drawing E101 dated 05/04/26.

ADDENDUM NO. 1  
Special Education Alterations to  
Centennial High School  
Williamson County Schools  
J+B No. 2519  
WCS RFB #1408  
May 4, 2026  
Page 3

**DRAWING E201**

**REFERENCE: 1/E201 LIGHTING PLAN**

REVISE: Location of calm room lighting scope as shown on the attached revised drawing E201 dated 05/04/26.

**REFERENCE: 4/E201 POWER & SYSTEMS PLAN**

 
 

 










ADD: Fire alarm strobes at TLT. D-18 and TLT. D-19 as shown on the attached revised drawing E201 dated 05/04/26.

 - END OF ADDENDUM -

 ATTACHMENTS: Drawing A1.1 dated 05-04-26  
Drawing A1.2 dated 05-04-26  
Drawing A2.1 dated 05-04-26  
Drawing A2.2 dated 05-04-26  
Drawing A9.1 dated 05-04-26  
Drawing A9.2 dated 05-04-26  
Drawing E101 dated 05-04-26  
Drawing E201 dated 05-04-26  
Drawing PFP201 dated 05-04-26  
Drawing M201 dated 05-04-26

 



 

 

 

 


**WALL SYMBOLS LEGEND**


-  EXISTING C.M.U. WITH BRICK VENEER EXTERIOR WALL TO REMAIN
-  EXISTING C.M.U. WITH BRICK VENEER EXTERIOR WALL TO REMAIN
-  EXISTING 1-HOUR C.M.U. WALL SEALED TIGHT TO BOTTOM OF DECK
-  EXISTING 2-HOUR C.M.U. WALL SEALED TIGHT TO BOTTOM OF DECK
-  EXISTING 4-HOUR C.M.U. WALL SEALED TIGHT TO BOTTOM OF DECK
-  EXISTING C.M.U. WALL SEALED TIGHT TO BOTTOM OF DECK TO REMAIN
-  EXISTING C.M.U. WALL - EXTENDED 4' ABOVE CEILING
-  EXISTING SMOKE BARRIER C.M.U. WALL SEALED TIGHT TO BOTTOM OF DECK
-  30 MINUTES C.M.U. WALL SEALED TIGHT TO BOTTOM OF DECK
-  EXISTING C.M.U. WALL TO BE REMOVED
-  EXISTING METAL STUD WALL WITH 5/8" TYPE "X" GYP. BD. EACH SIDE RUN 4' ABOVE CEILING
-  EXISTING SMOKE BARRIER METAL STUD WALL WITH 5/8" TYPE "X" GYP. BD. EACH SIDE SEALED TIGHT TO BOTTOM OF DECK.
-  NEW METAL STUD WALL WITH 5/8" TYPE "X" GYP. BD. EACH SIDE W/SOUND INSULATION
-  NEW METAL STUD WALL WITH 5/8" TYPE "X" GYPSUM BOARD ON ONE OR BOTH SIDES

\* EXTEND ALL NEW WALLS TIGHT TO DECK ABOVE AND FILL BETWEEN FLUTES OF METAL DECK, UNLESS OTHERWISE NOTED.


**FULLY PROTECTED BY AUTOMATIC SPRINKLER SYSTEM  
LEGEND**

-  ACTUAL MAX. TRAVEL DISTANCE TO EXIT
-  NEW COMBINATION EXIT & EMERGENCY LIGHT
-  EXISTING COMBINATION EXIT & EMERGENCY LIGHT
-  EXISTING EMERGENCY LIGHT
-  F.E.C. NEW FIRE EXTINGUISHER CABINET
-  F.E.C. EXISTING FIRE EXTINGUISHER CABINET
-  SMOKE BARRIER
-  30 MIN. RATED
-  1 HOUR FIRE RATED
-  2 HOUR FIRE RATED
-  4 HOUR FIRE RATED

- I.B.C.:
- MINIMUM CORRIDOR WIDTH = 6'-0"
  - MAXIMUM ALLOWABLE TRAVEL DISTANCE TO AN EXIT = 250'
  - HORIZONTAL EXIT WIDTH REQUIRED PER OCCUPANT = 0.15'
- NFPA 101:
- MINIMUM CORRIDOR WIDTH = 6'-0"
  - MAXIMUM ALLOWABLE TRAVEL DISTANCE TO AN EXIT = 200'
  - HORIZONTAL EXIT WIDTH REQUIRED PER OCCUPANT = 0.2'

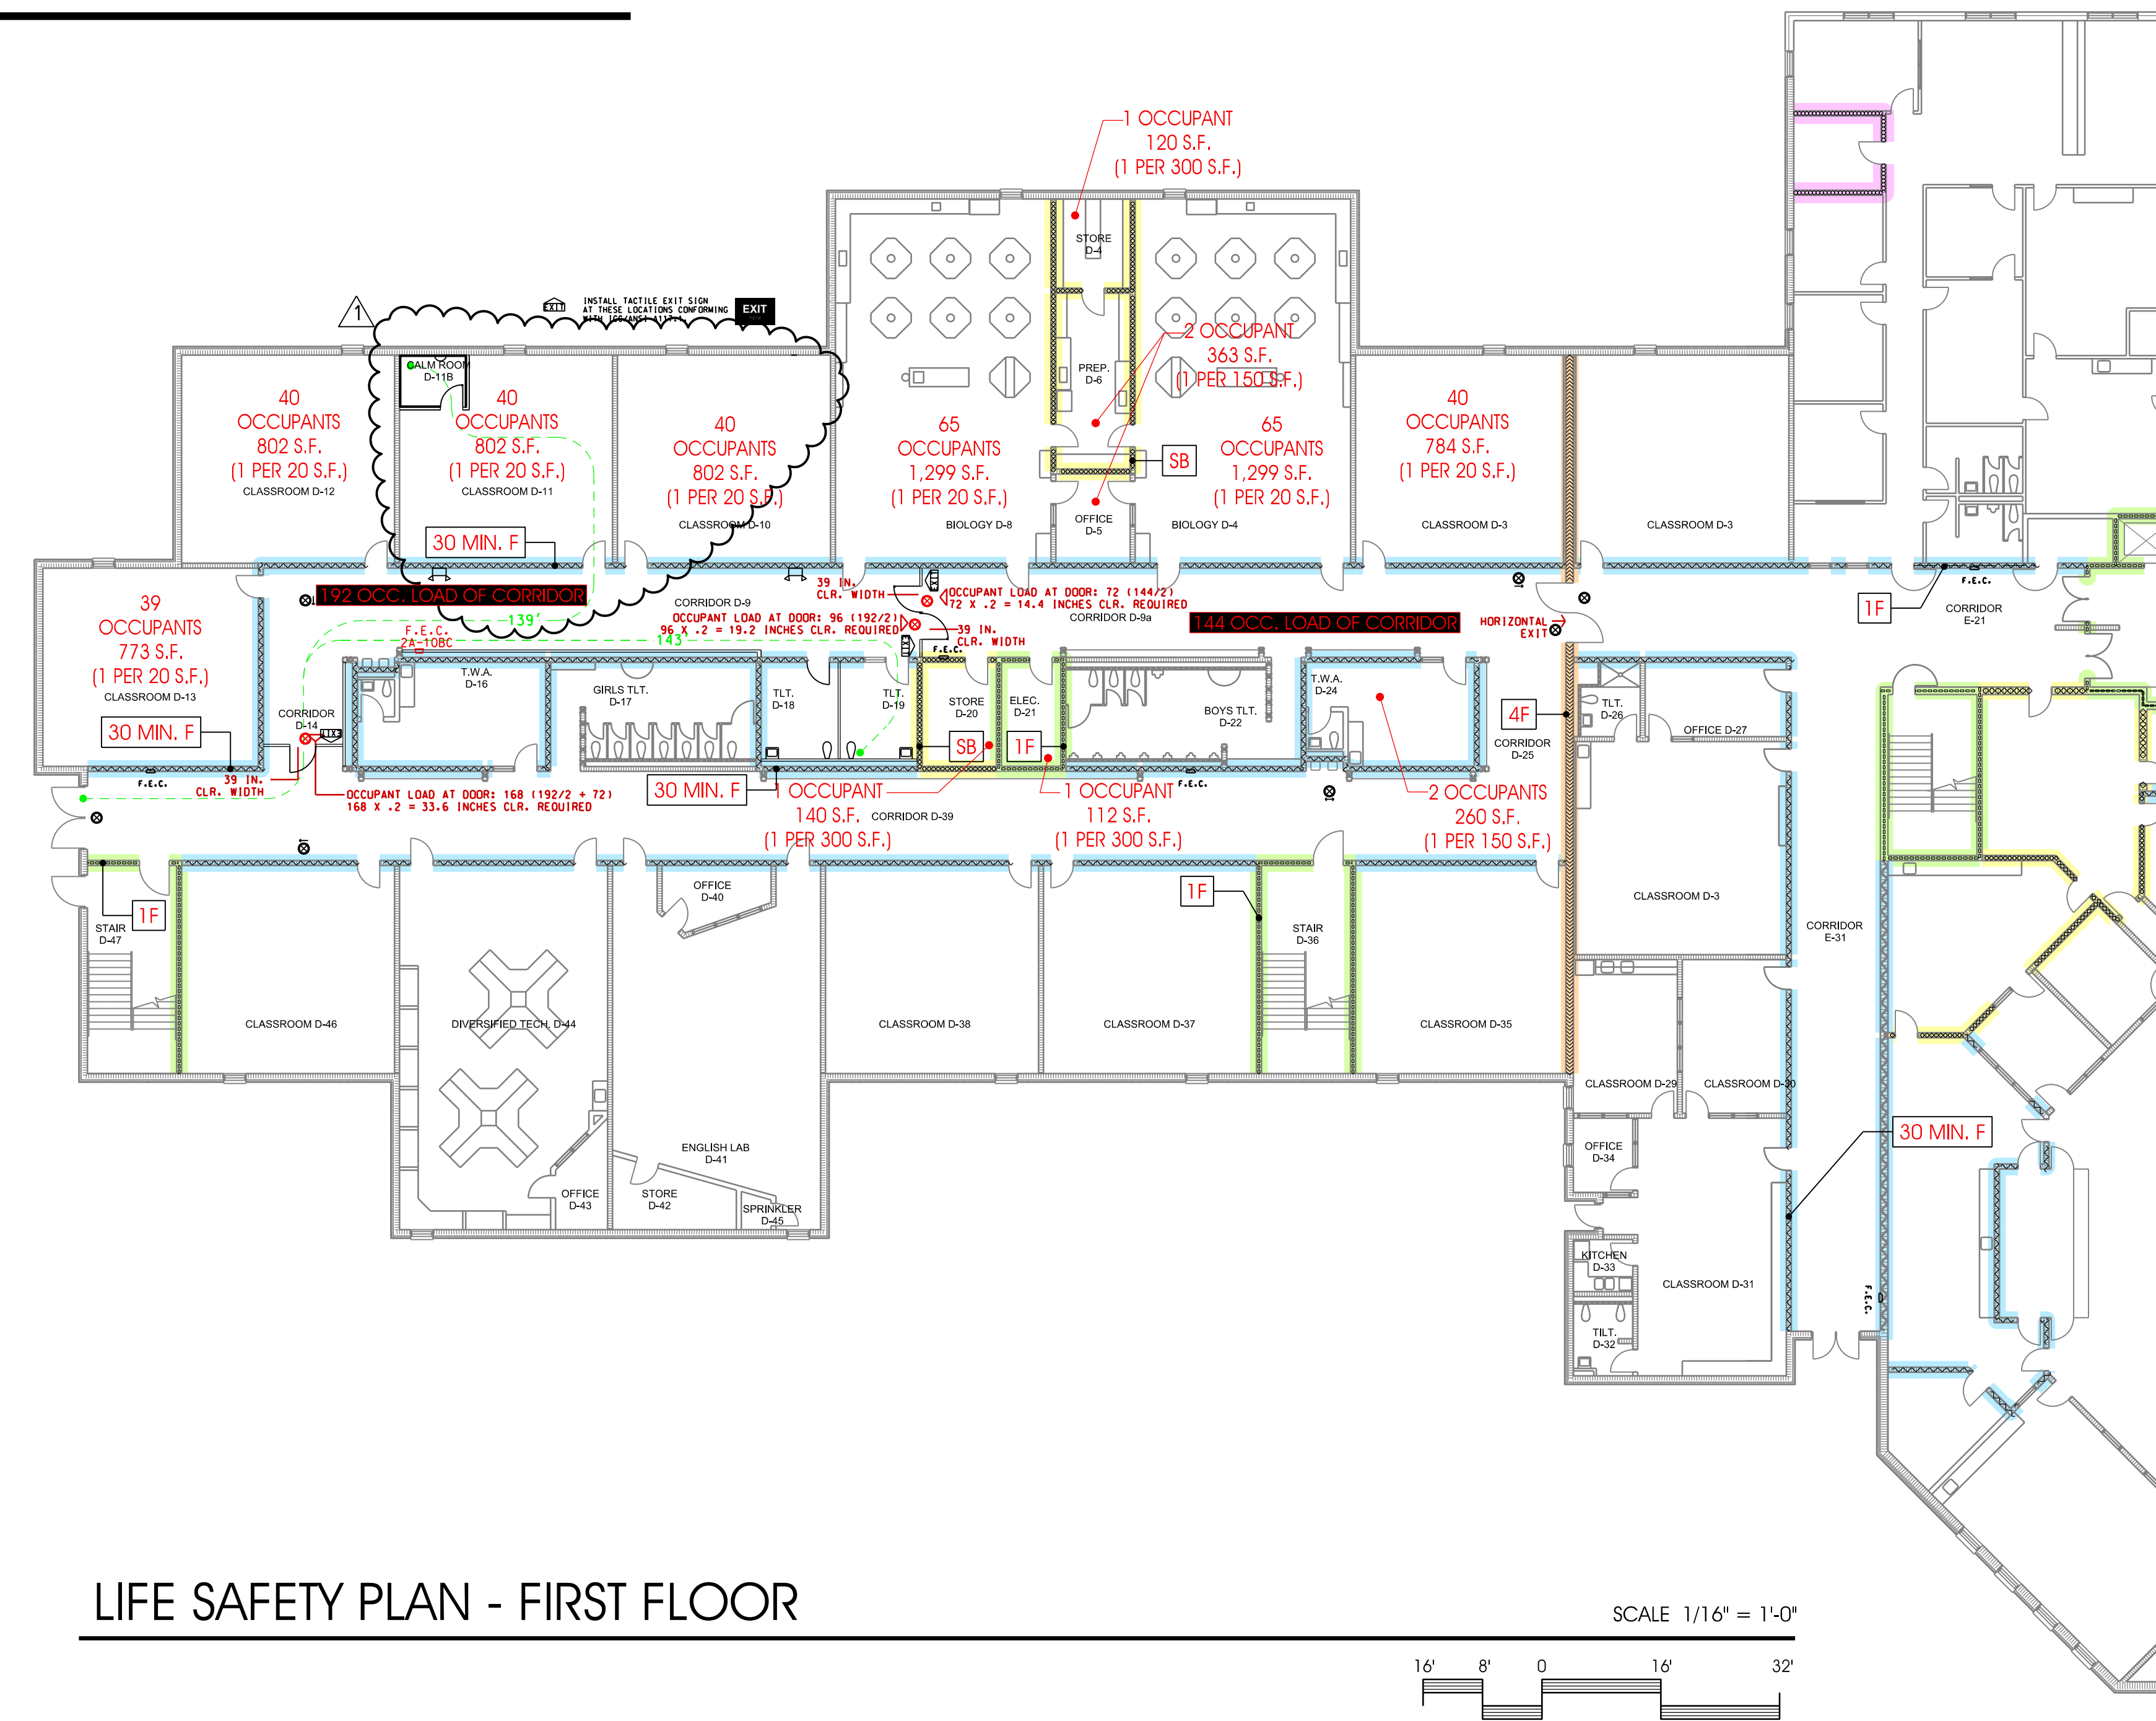

**LIFE SAFETY PLAN - FIRST FLOOR**

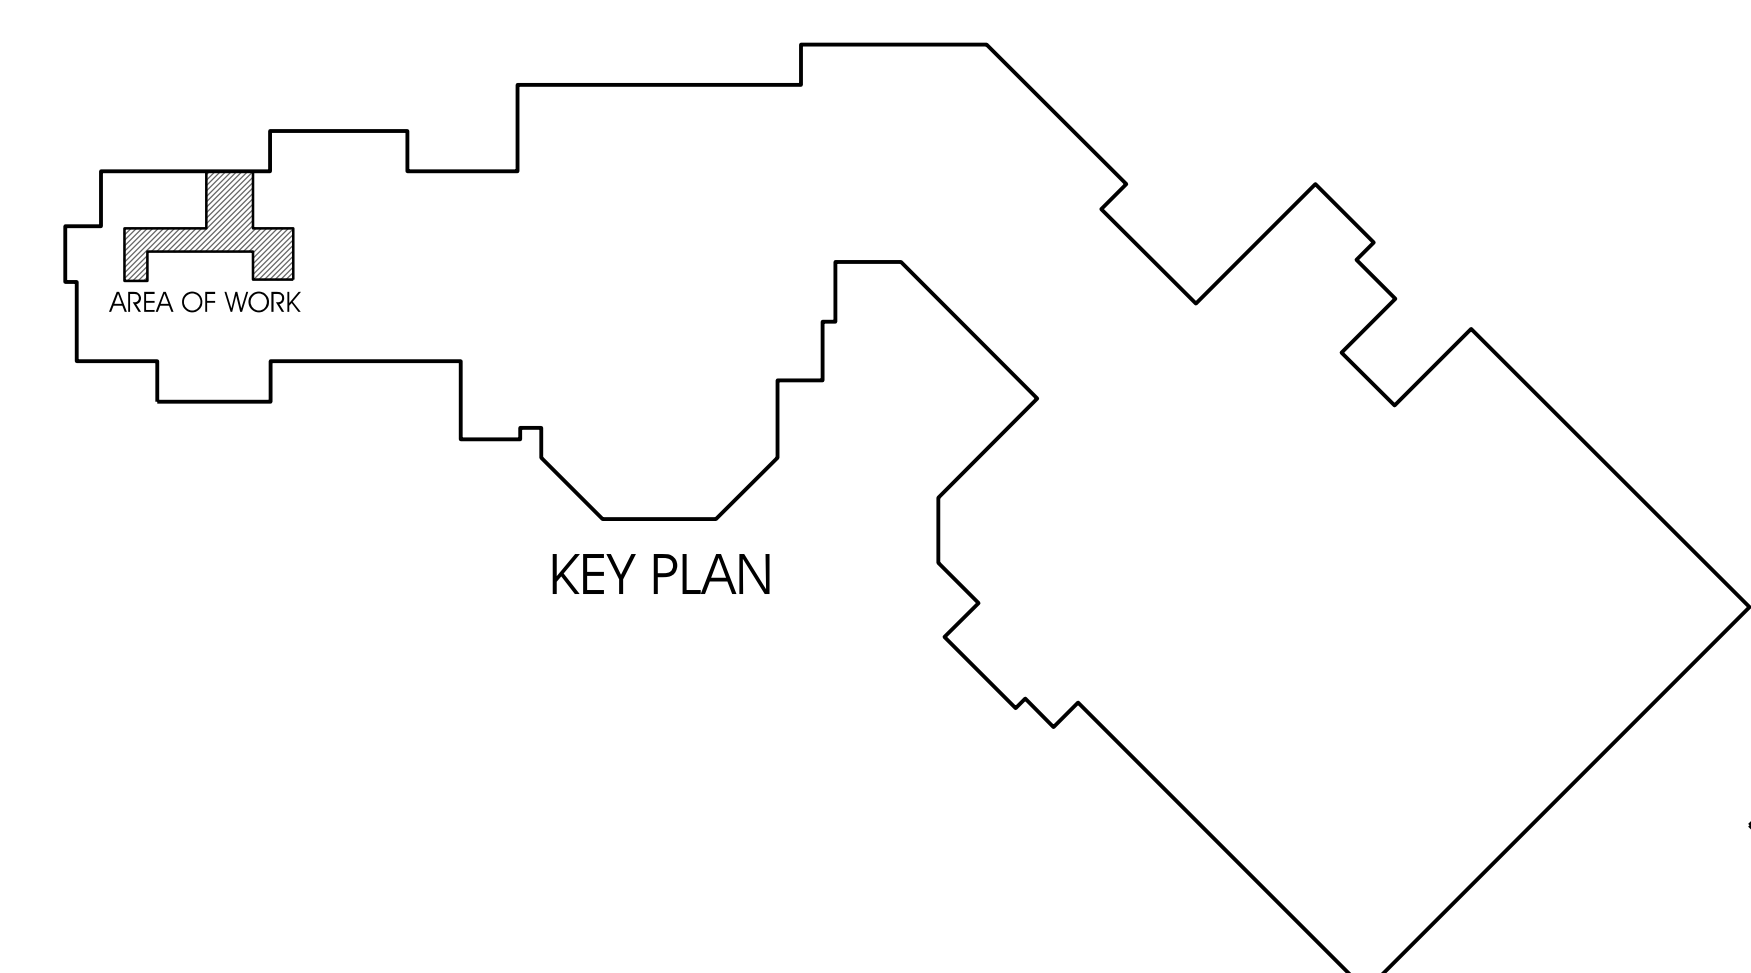

City Center  
100 East Vine St.  
Murfreesboro Tennessee  
37130  
615-890-4560  
Fax: 615-890-4564


**Special Education  
Alterations to  
Centennial  
High School**

Williamson County Schools

| REVISION      | DATE     |
|---------------|----------|
| 1 ADDENDUM #1 | 05-04-26 |

NOTES:

THIS DRAWING SHALL NOT BE REPRODUCED, PUBLISHED, OR USED IN ANY WAY WITHOUT THE WRITTEN PERMISSION OF THE ARCHITECT.

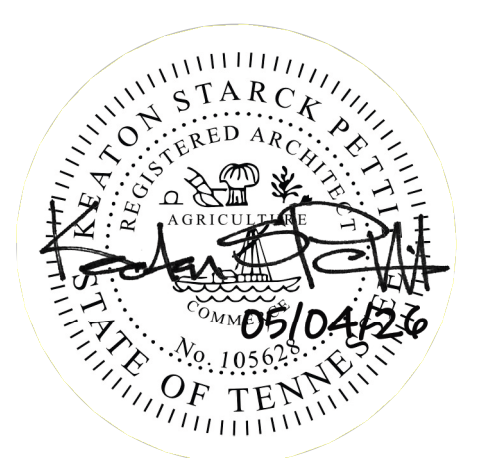

PROJECT NO. 2519  
DATE 03-10-26  
DRAWN BY C.L.C.  
CHECKED BY K.S.P.

**A1.2**

**GENERAL RENOVATION NOTES**

- A. WORK AREA IS TO BE SECURED AT END OF EACH WORK DAY.
- B. PATCH & REPAIR EXISTING CONSTRUCTION WHERE EXISTING ITEMS ARE REMOVED OR NEW ITEMS ARE INSTALLED TO MATCH ADJACENT EXISTING CONSTRUCTION.
- C. PREPARE ALL EXISTING C.M.U. WALLS TO RECEIVE NEW PAINT IN AREAS INDICATED.
- D. REFER TO MECHANICAL, PLUMBING AND ELECTRICAL DRAWINGS FOR REMOVAL/REINSTALLATION OF ITEMS AS REQUIRED.


**DEMOLITION PLAN NOTES**

- 1. REMOVE EXISTING LOCKERS IN AREA INDICATED.
- 2. REMOVE EXISTING C.M.U. WALL (INCLUDING DOOR WHERE INDICATED), PATCH AND REPAIR EXISTING FLOOR TO MATCH ADJACENT CONSTRUCTION.
- 3. REMOVE AND STORE SECTION OF WALL AND BASE CABINETS.
- 4. REMOVE EXISTING PLUMBING FIXTURES INDICATED AND STORE FOR REUSE OR REPAIR. PROVIDE SPACE FOR NEW DOOR AND FRAME. SEE STRUCTURAL DETAIL 1/19.2. SCAN WALL FOR EXISTING REBAR, LOCATIONS AND LOCATE DOOR BETWEEN VERT. REINFORCING.
- 5. REMOVE PORTION OF EXISTING LOCKER CONCRETE BASE.
- 6. REMOVE PORTION OF EXISTING LOCKER CONCRETE BASE.
- 7. REMOVE PORTION OF WALL WHERE NEW WALLS TO BE ADDED CLEAN AND PREP AREA AS NEEDED FOR ISOLATION ROOM BUILD OUT.



**WALL SYMBOLS LEGEND**

- EXISTING C.M.U. WITH BRICK VENEER EXTERIOR WALL TO REMAIN
- EXISTING C.M.U. WITH BRICK VENEER EXTERIOR WALL TO REMAIN
- EXISTING 1-HOUR C.M.U. WALL SEALED TIGHT TO BOTTOM OF DECK
- EXISTING 2-HOUR C.M.U. WALL SEALED TIGHT TO BOTTOM OF DECK
- EXISTING 4-HOUR C.M.U. WALL SEALED TIGHT TO BOTTOM OF DECK
- EXISTING C.M.U. WALL SEALED TIGHT TO BOTTOM OF DECK TO REMAIN
- EXISTING C.M.U. WALL - EXTENDED 4' ABOVE CEILING
- EXISTING SMOKE BARRIER C.M.U. WALL SEALED TIGHT TO BOTTOM OF DECK
- 30 MINUTES C.M.U. WALL SEALED TIGHT TO BOTTOM OF DECK
- EXISTING C.M.U. WALL TO BE REMOVED
- 
- 
- 
- 


\* EXTEND ALL NEW WALLS TIGHT TO DECK ABOVE AND FILL BETWEEN FLUTES OF METAL DECK, UNLESS OTHERWISE NOTED.

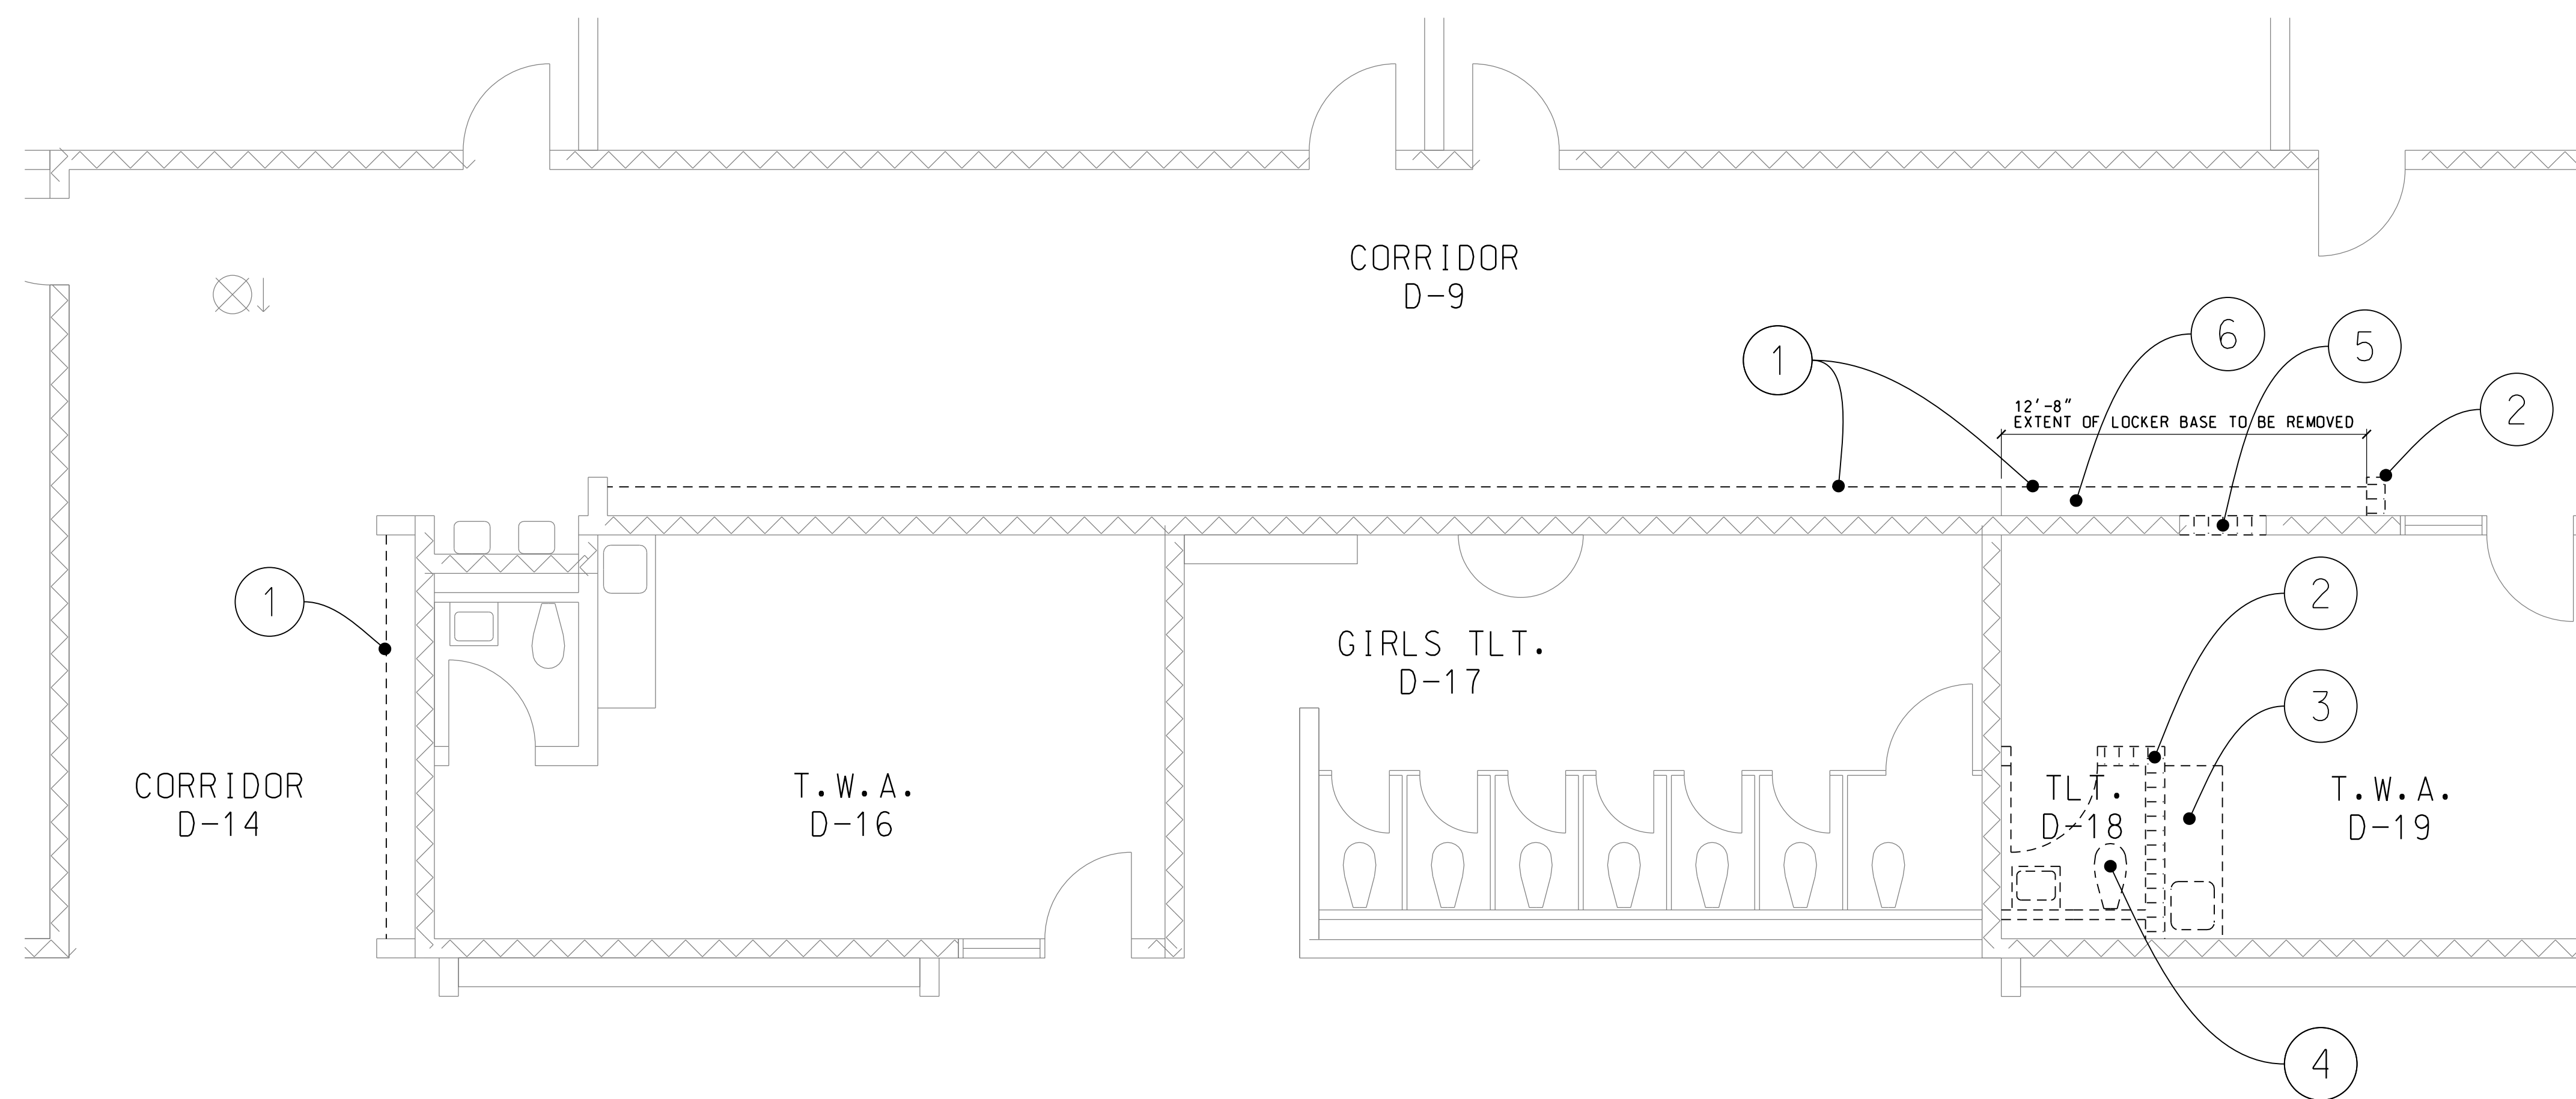

**DEMOLITION FLOOR PLAN**

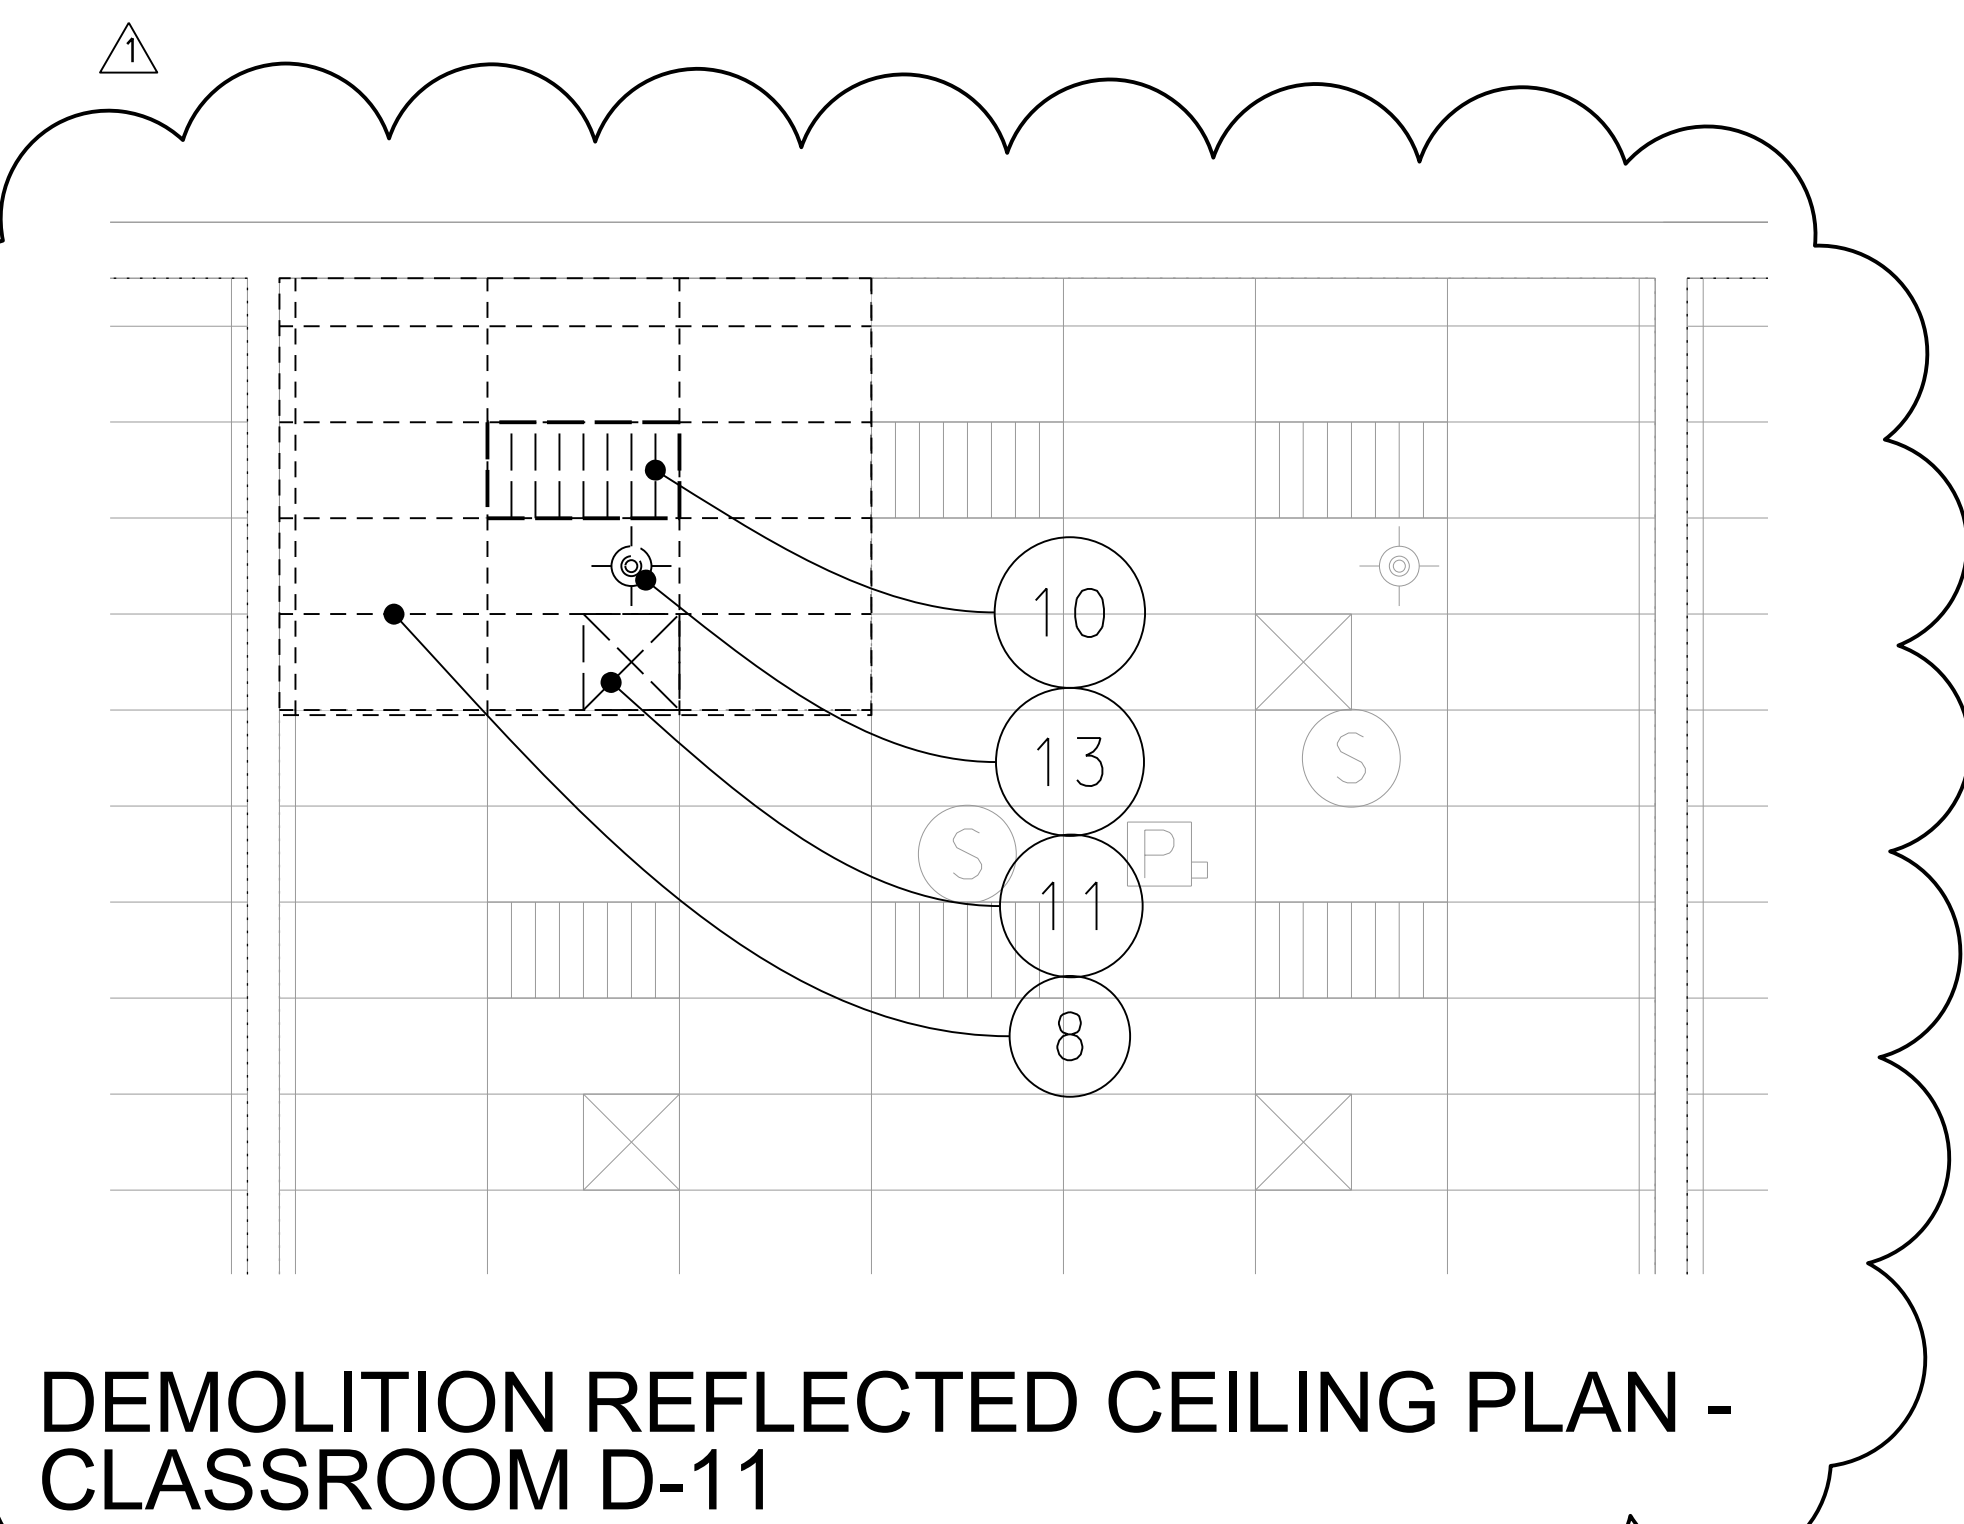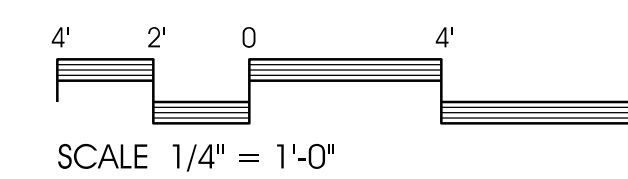

**DEMOLITION REFLECTED CEILING PLAN - CLASSROOM D-11**

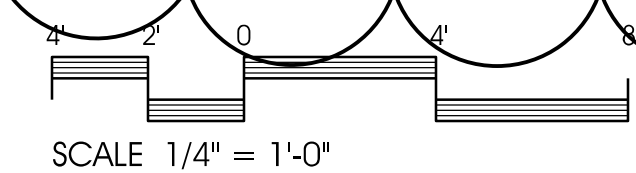


**DEMOLITION - REFLECTED CEILING NOTES**



- 8. REMOVE EXISTING CEILING GRID AND TILE TO EDGE OF NEW WALL TO BE INSTALLED. INSTALL NEW WALL TRIM AS REQUIRED.
- 9. REMOVE EXISTING CEILING GRID AND TILE TO THE NEAREST CROSS TEE.
- 10. REMOVE AND STORE EXISTING LIGHT FIXTURES FOR RE-INSTALLATION IN NEW GRID AFTER INSTALLATION IS COMPLETE. SEE ELECTRICAL DRAWINGS.
- 11. REMOVE EXISTING HVAC DEVICE. STORE FOR RE-INSTALLATION.
- 12. REMOVE AND STORE EXISTING EXIT LIGHT AND / OR CAMERA FOR RE-INSTALLATION AFTER NEW GRID AND TILE INSTALLATION IS COMPLETE. SEE ELECTRICAL DRAWINGS.
- 13. RELOCATE AND ADD NEW SPRINKLER HEADS AS REQUIRED. SEE FIRE PROTECTION PLAN.

**REFLECTED CEILING PLAN LEGEND**

- EXISTING LAY-IN ACOUSTICAL TILE CEILING TO REMAIN
- EXISTING LAY-IN ACOUSTICAL TILE CEILING TO BE REMOVED
- NEW LAY-IN ACOUSTICAL TILE CEILING
- NEW GYPSUM BOARD BULKHEAD
- EXISTING RECESSED 2 X 4 FIXTURE TO REMAIN
- EXISTING RECESSED 2 X 4 FIXTURE TO BE REMOVED
- NEW RECESSED 2 X 4 FIXTURE
- EXISTING EXIT LIGHT TO REMAIN
- EXISTING EXIT LIGHT TO BE REMOVED
- NEW EXIT LIGHT
- EXISTING HVAC DEVICES TO REMAIN
- EXISTING HVAC DEVICES TO BE REMOVED
- NEW SUPPLY AIR DIFFUSER/EXHAUST GRILLE
- EXIST. CAMERA/NEW CAMERA - CLG. MT. (O.F.O.I.)
- EXIST. CAMERA/NEW CAMERA - WALL MT. (O.F.O.I.)
- EXISTING CEILING-MOUNTED SPEAKER TO BE REMOVED
- NEW CEILING-MOUNTED SPEAKER
- EXISTING SMOKE DETECTOR TO BE REMOVED
- NEW SMOKE DETECTOR
- NEW UNIT HEATER
- SPRINKLER HEAD - EXISTING
- SPRINKLER HEAD - NEW (NOTE: PROPOSED LOCATIONS SHOWN FOR COORDINATION PURPOSES ONLY)

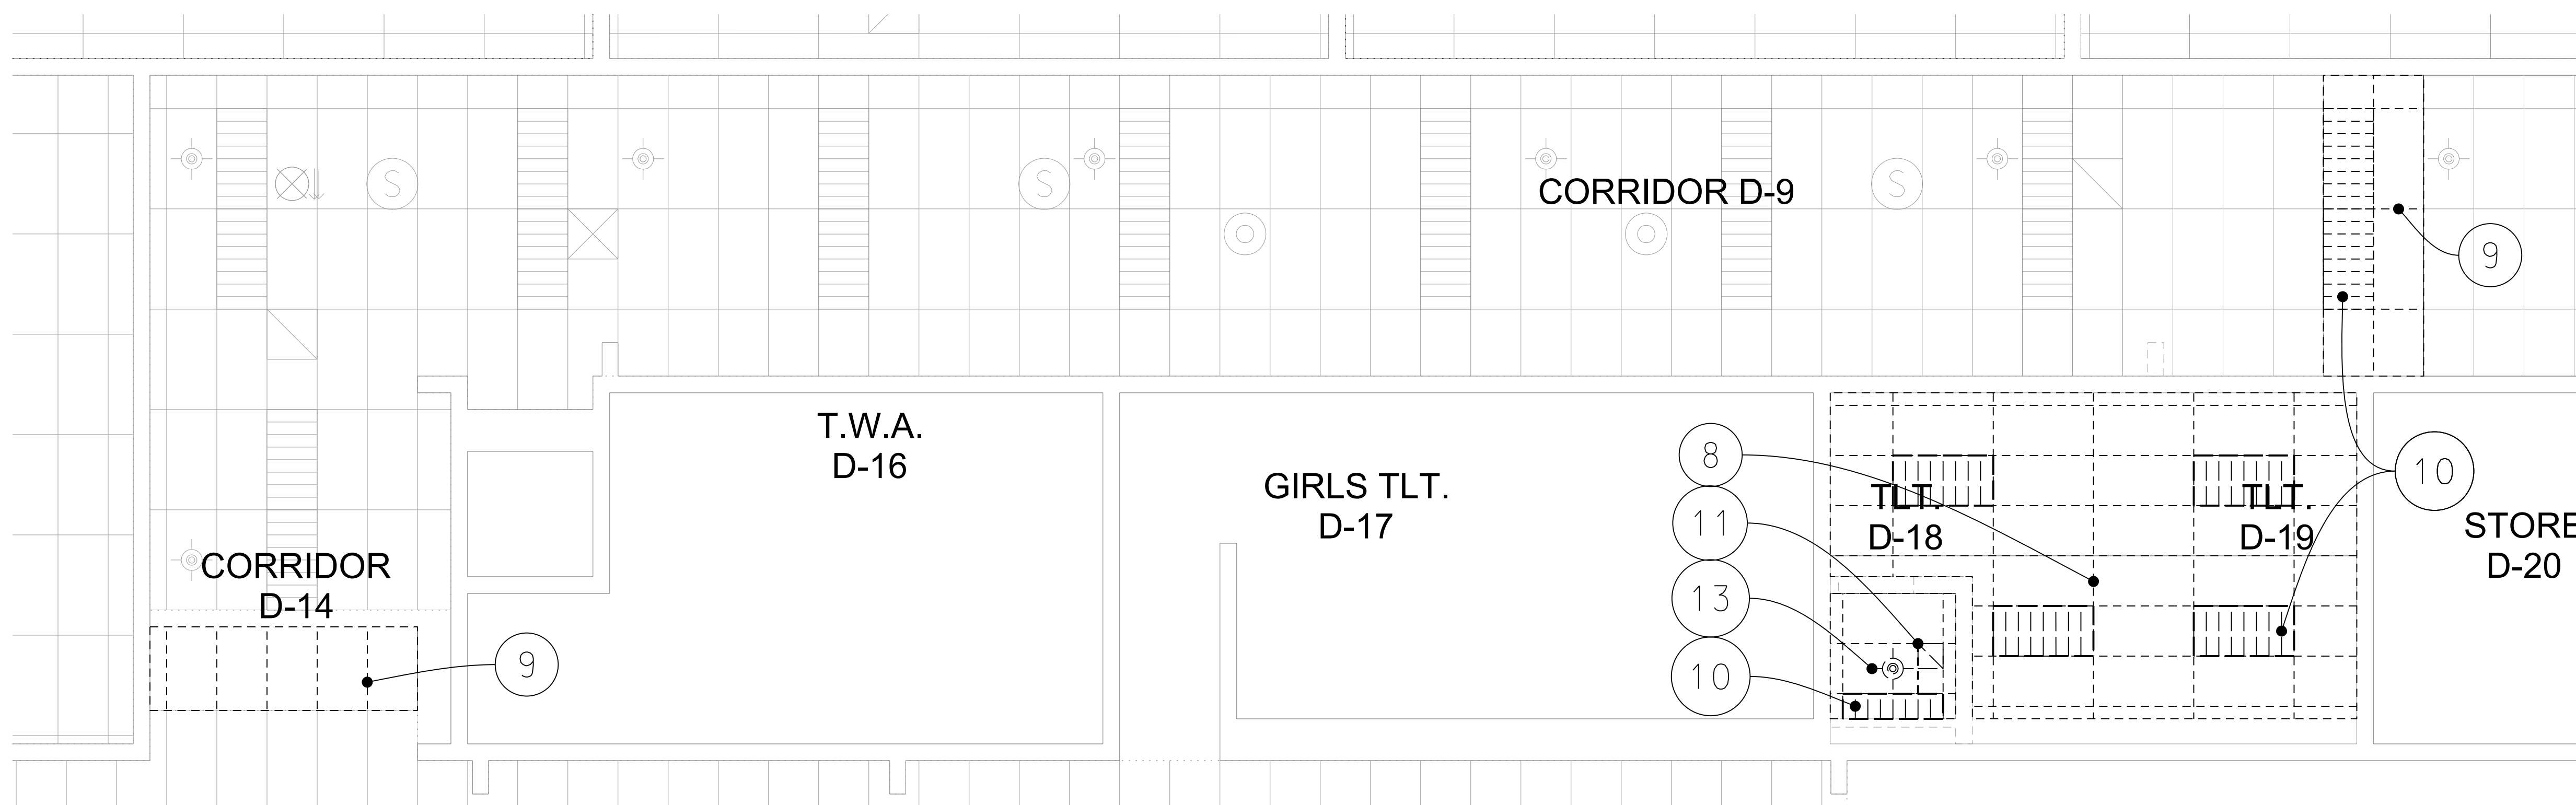


**DEMOLITION REFLECTED CEILING PLAN - CORRIDOR D-9, CORRIDOR D-14, TL.T. D-18, & T.W.A. D-19**

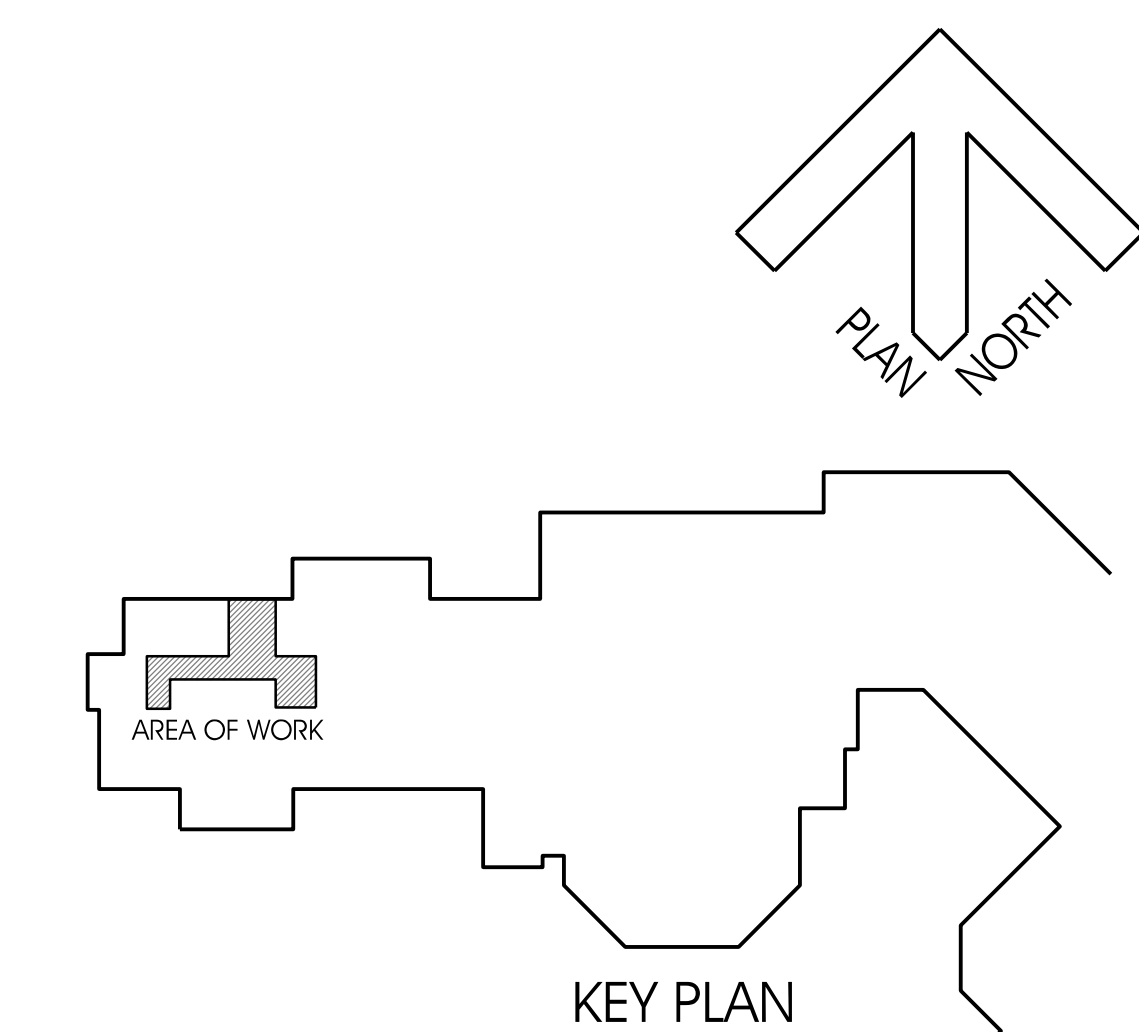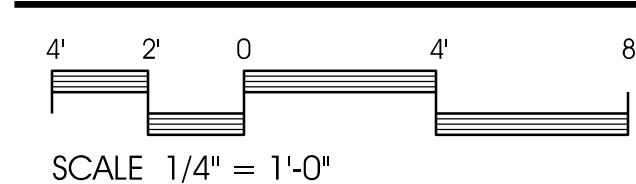


| REVISION       | DATE     |
|----------------|----------|
| 1. ADDENDUM #1 | 05-04-26 |

**NOTES:**


THIS DRAWING SHALL NOT BE REPRODUCED, PUBLISHED, OR USED IN ANY WAY WITHOUT THE WRITTEN PERMISSION OF THE ARCHITECT.

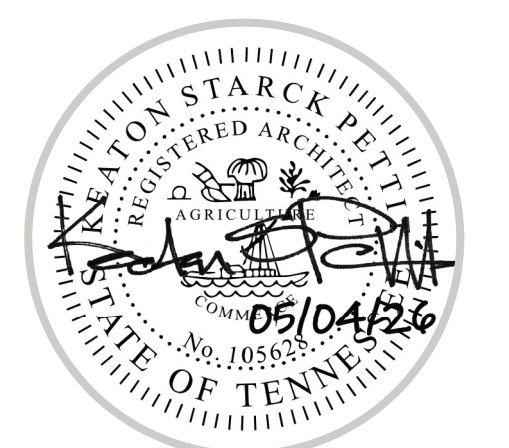



|             |          |
|-------------|----------|
| PROJECT NO. | 2519     |
| DATE        | 03-10-26 |
| DRAWN BY    | C.L.C.   |
| CHECKED BY  | K.S.P.   |

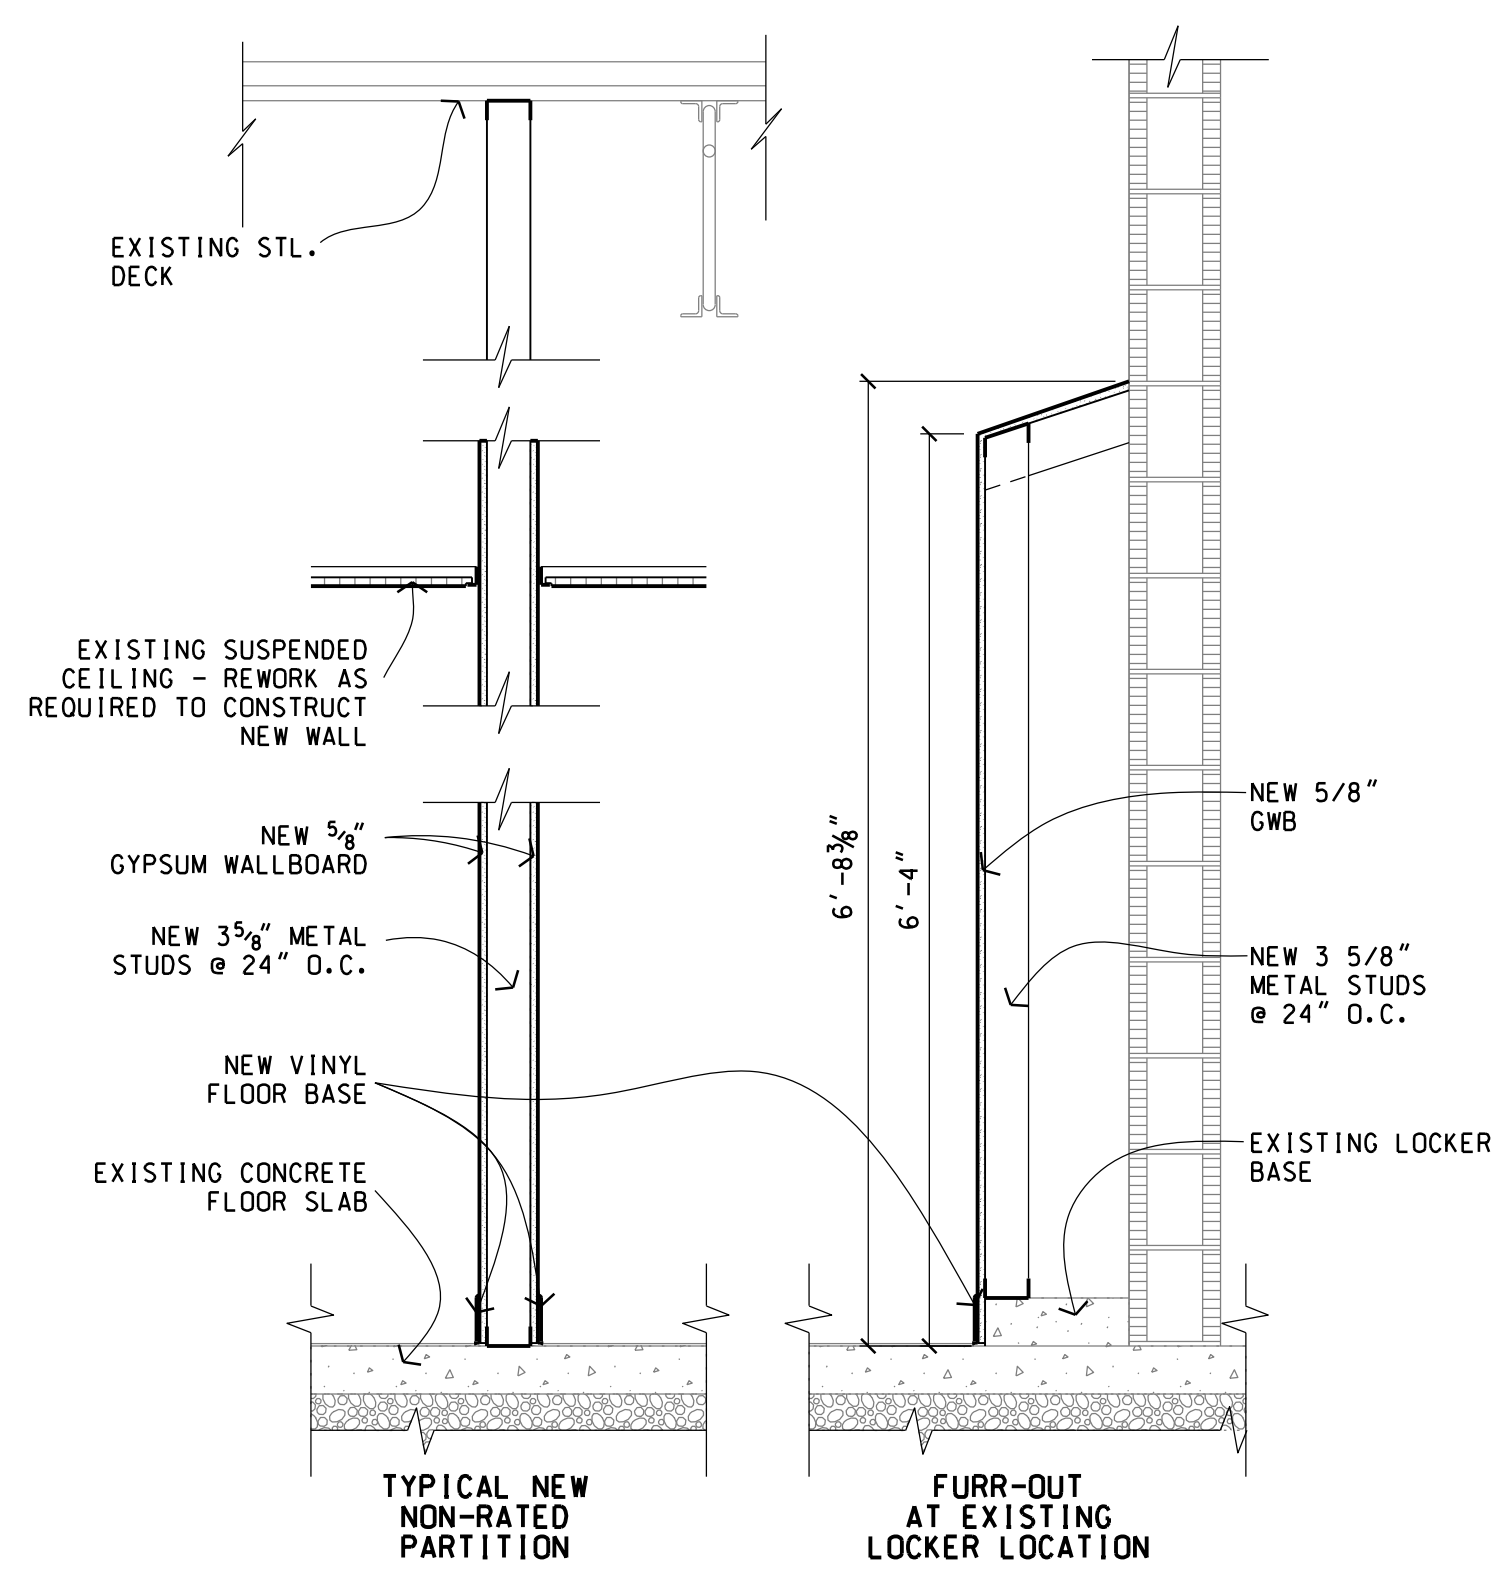




WALL SECTION

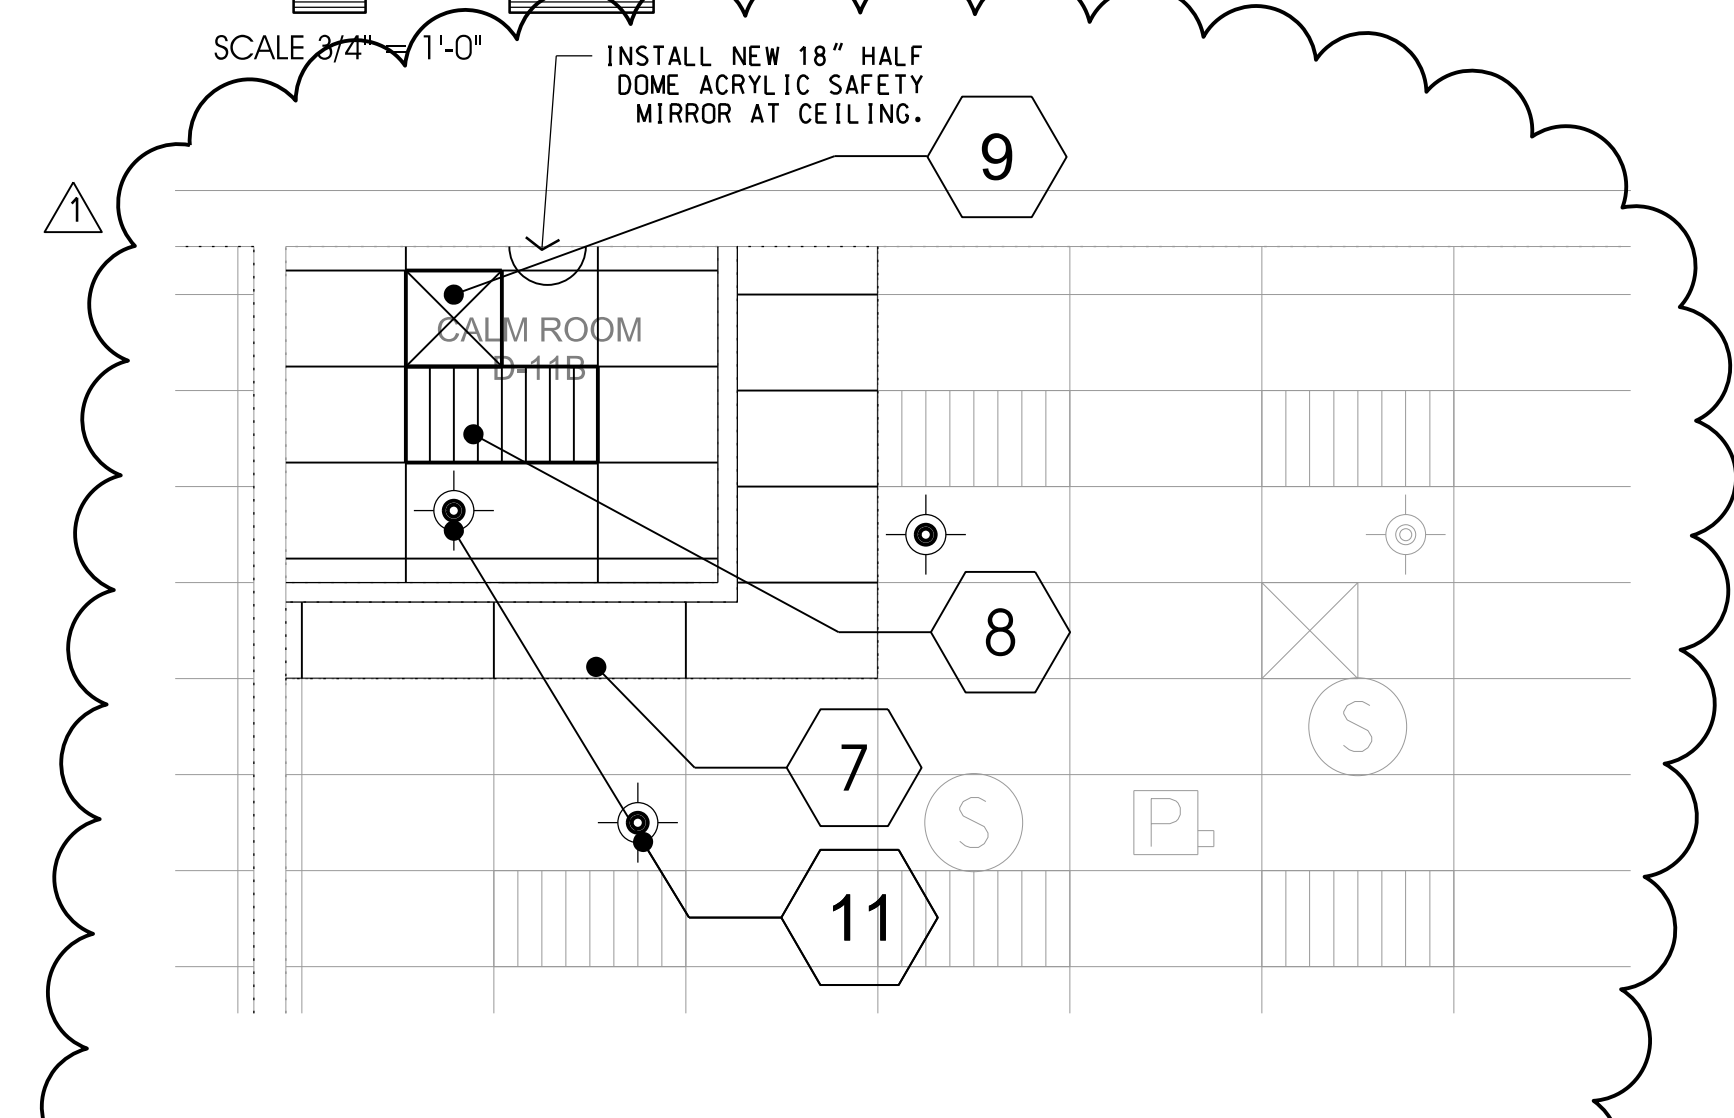


REFLECTED CEILING PLAN - NEW WORK - CLASSROOM D-11

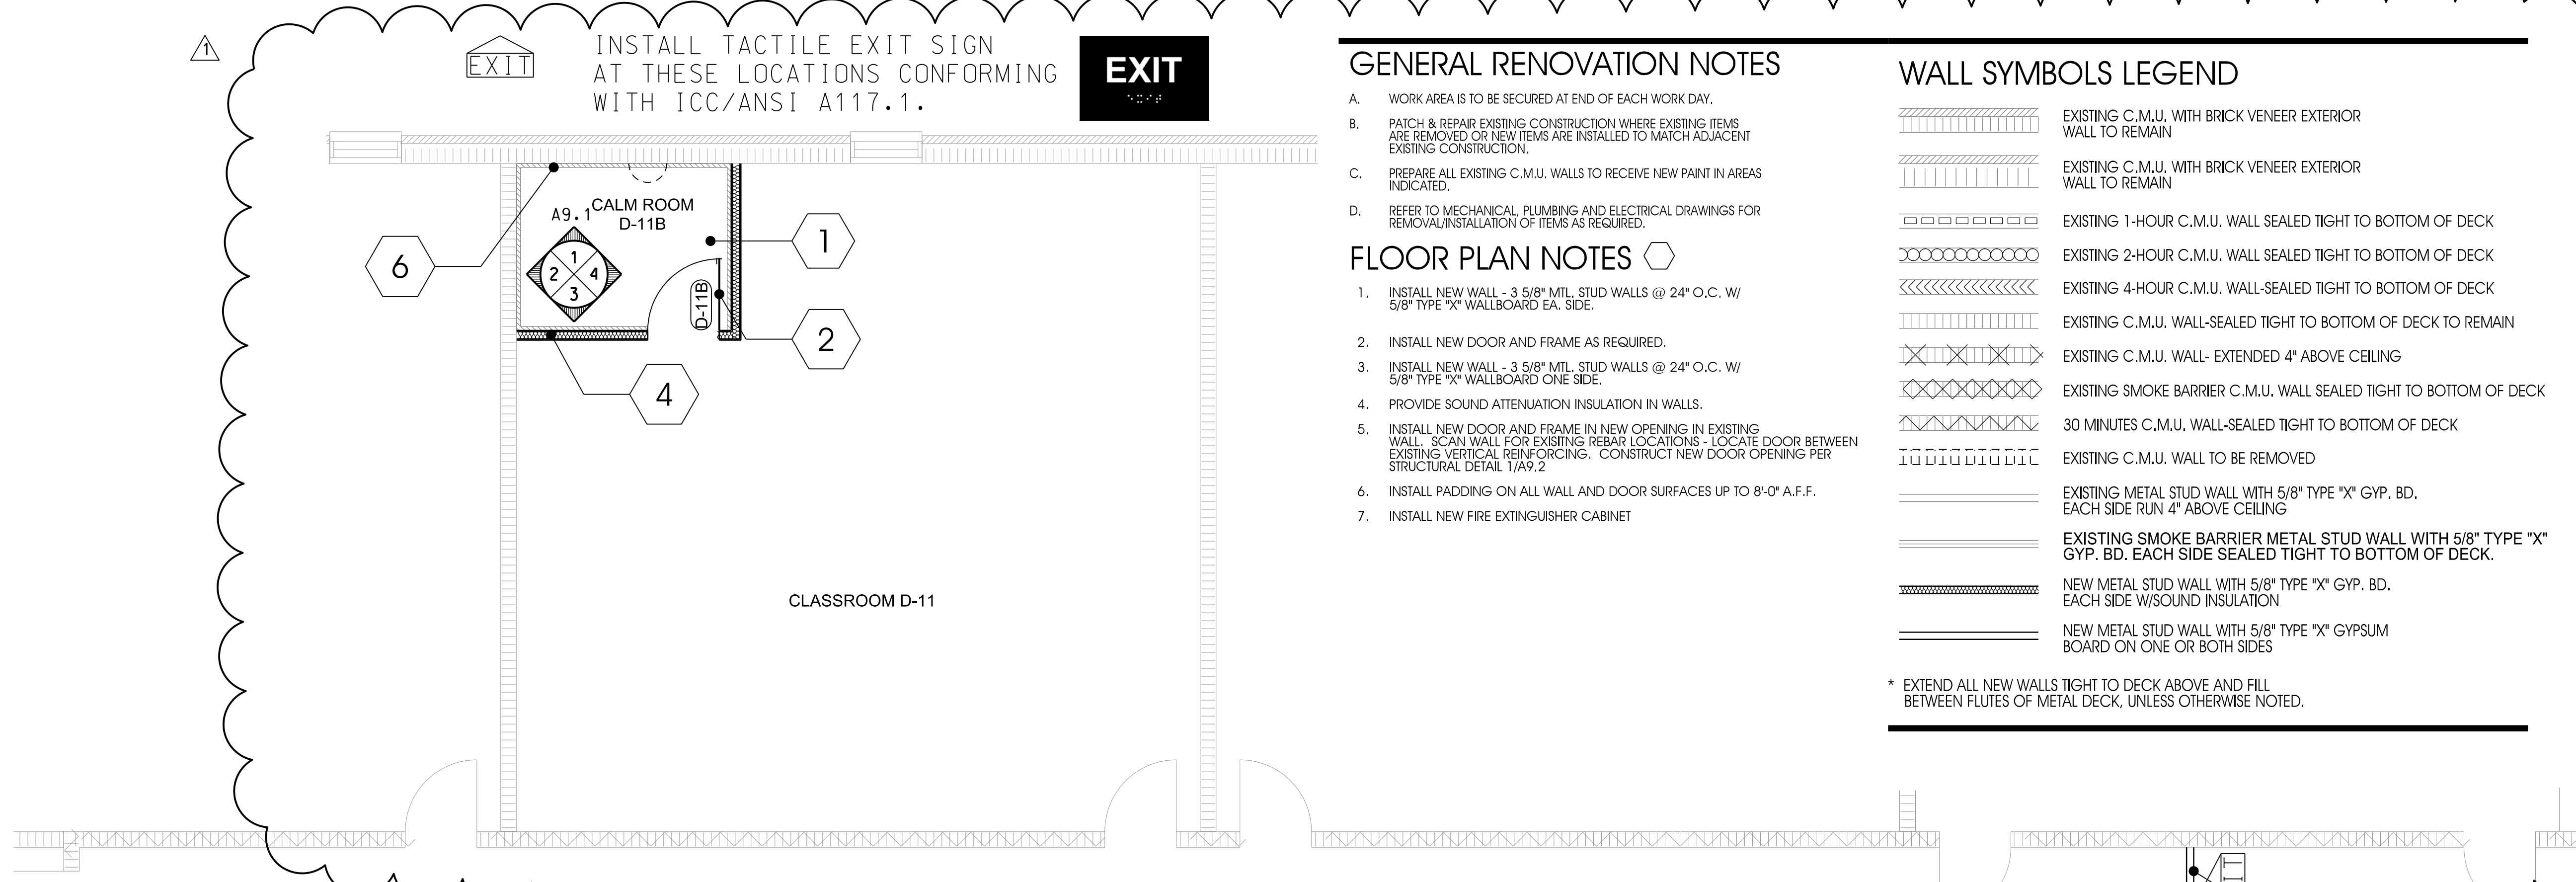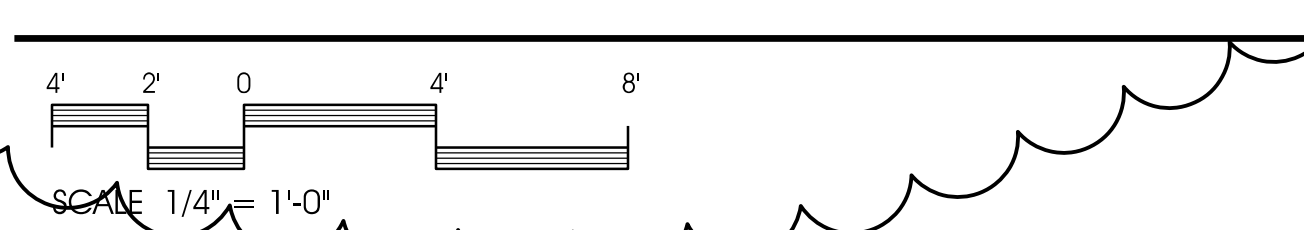

LARGE SCALE FLOOR PLAN

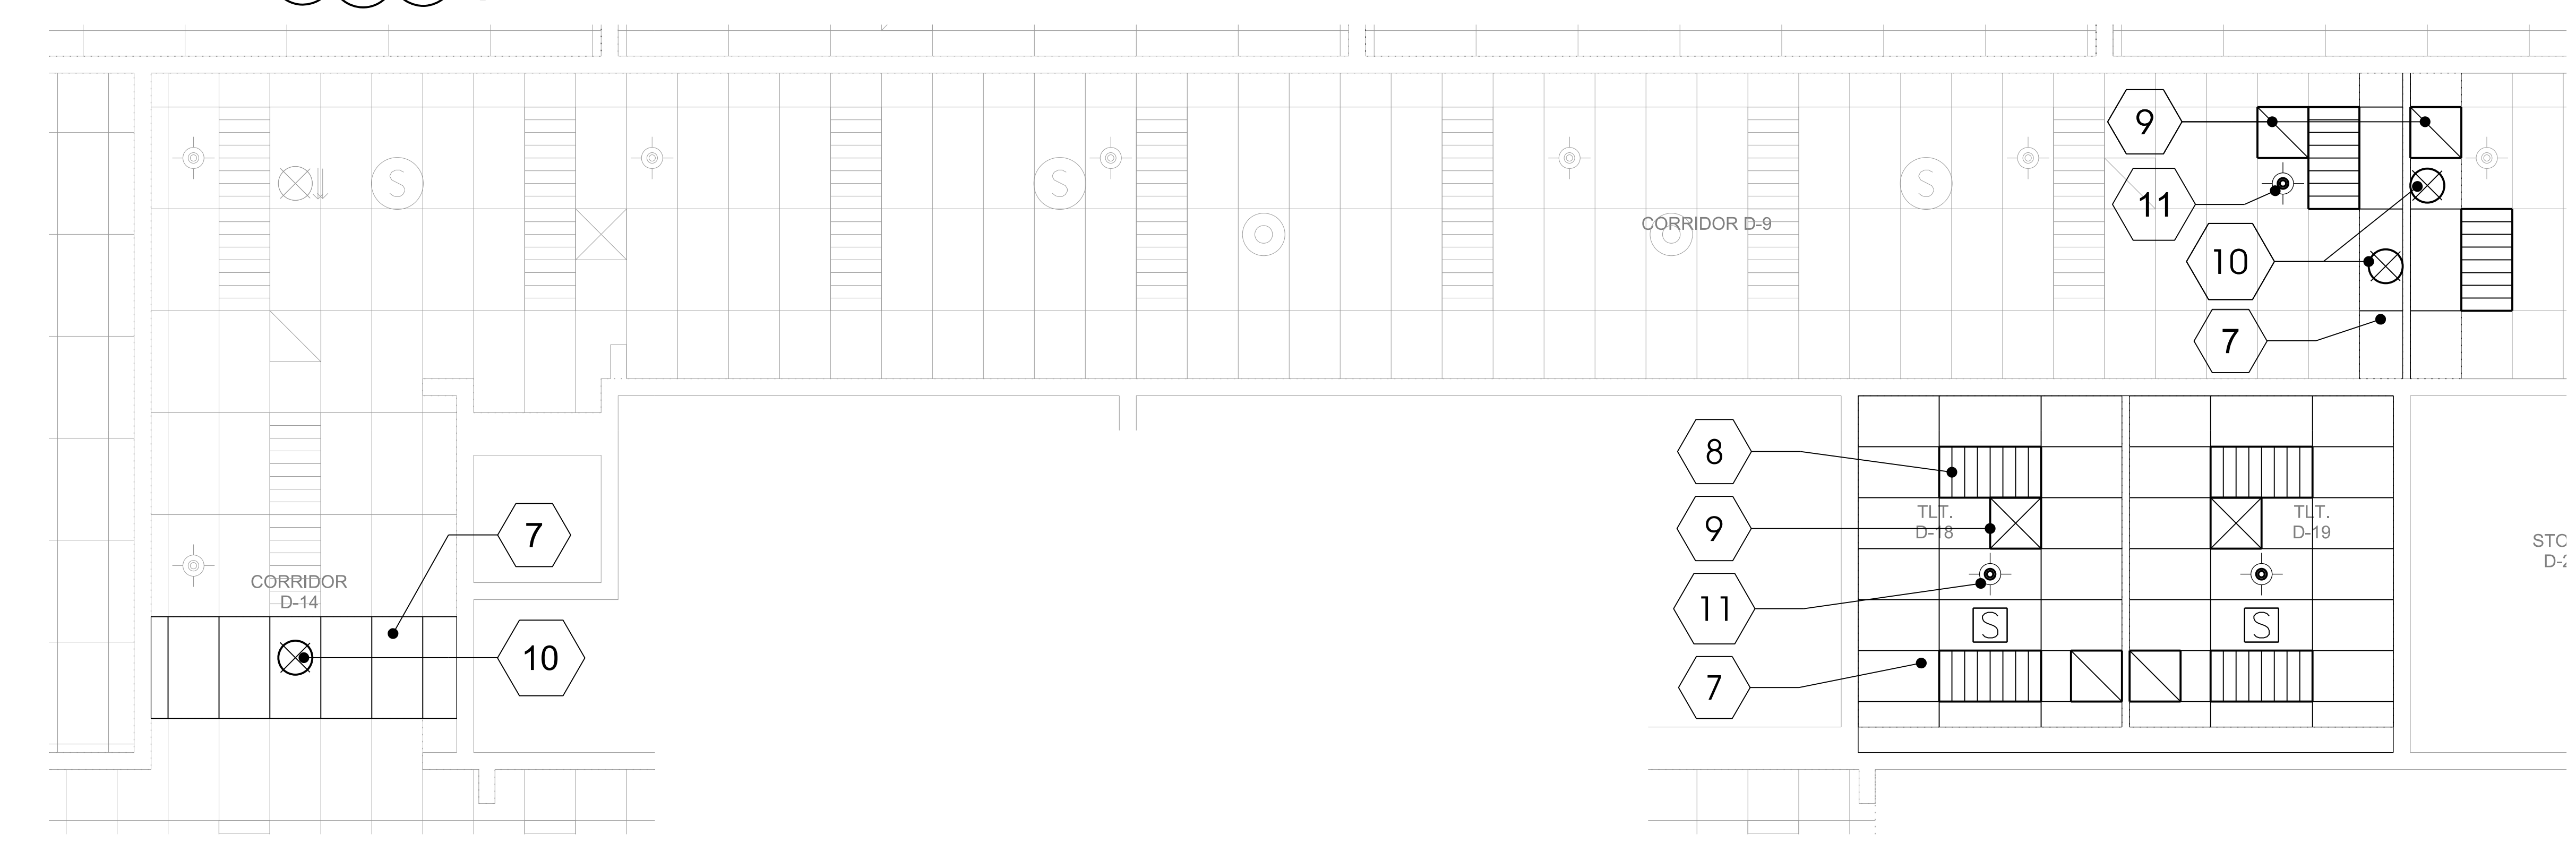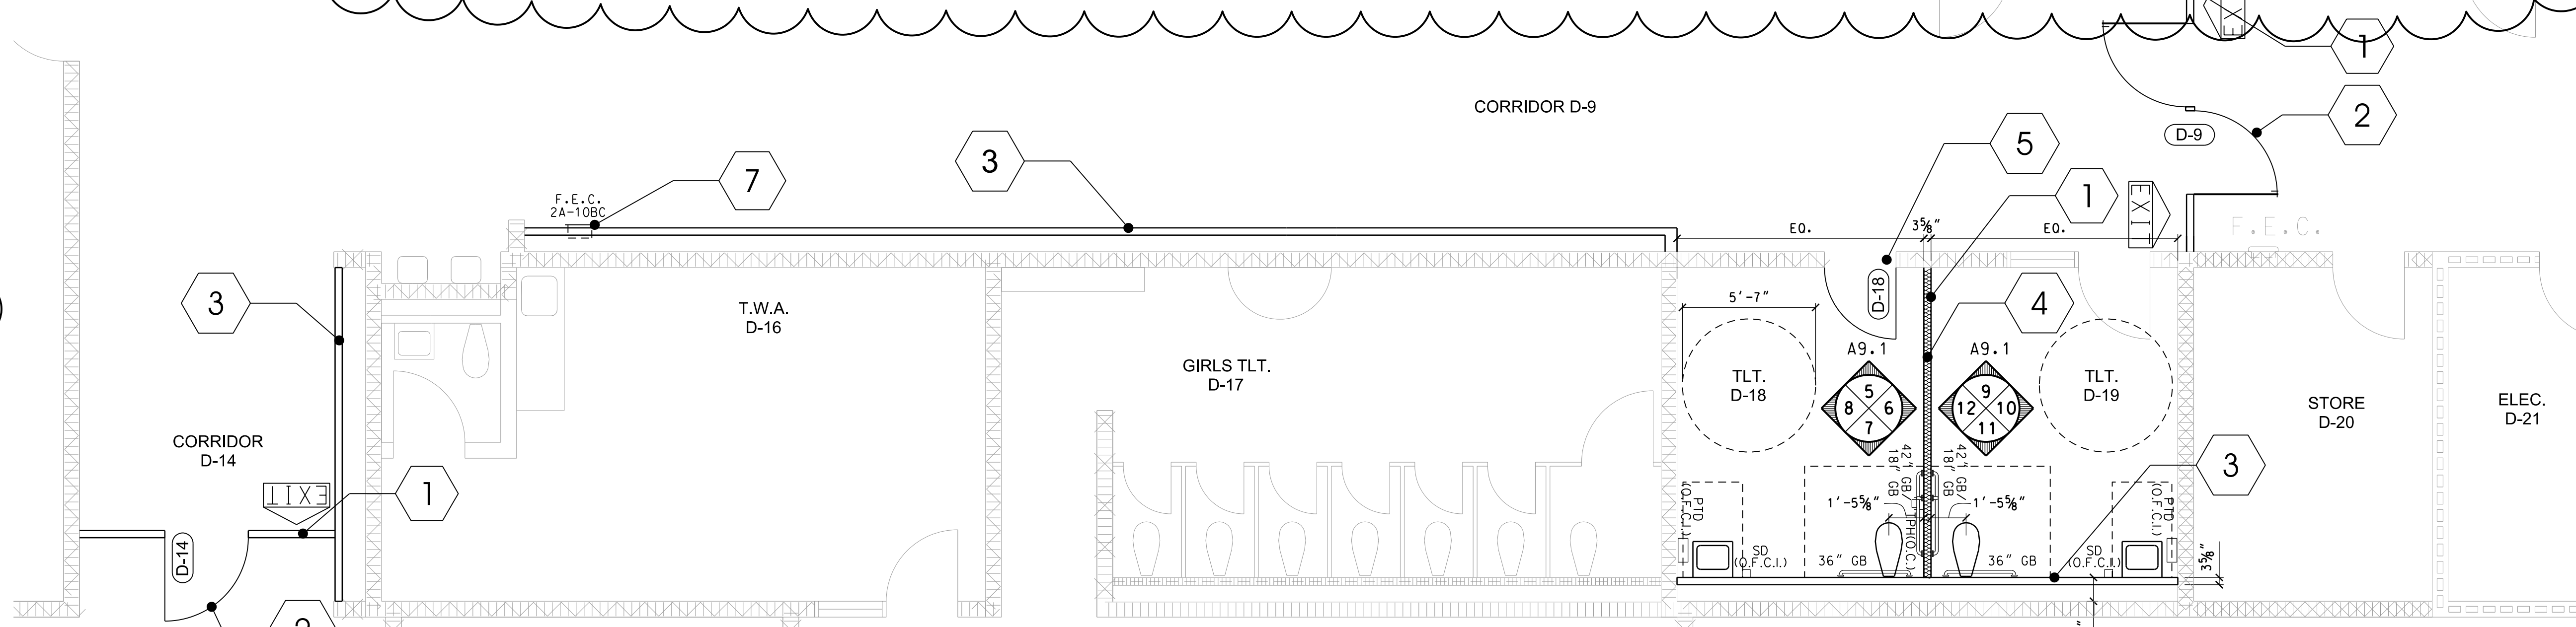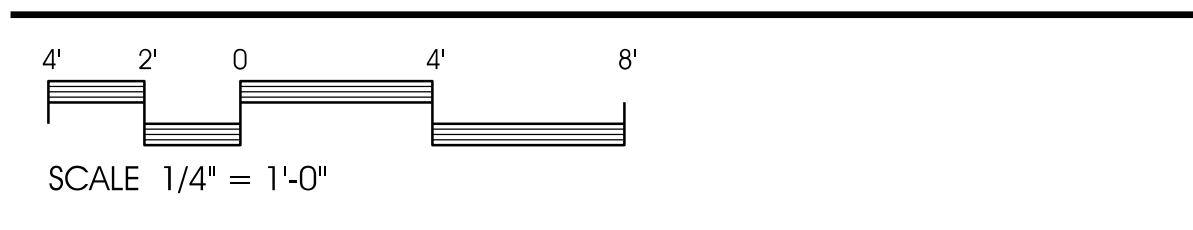

REFLECTED CEILING PLAN - NEW WORK - CORRIDOR D-9 AND D-14

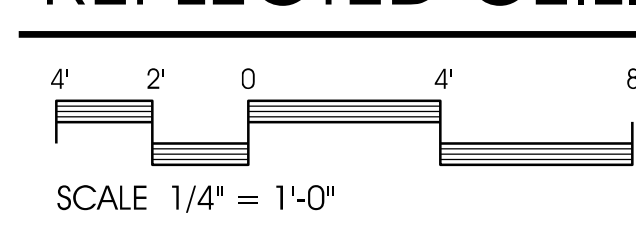

GENERAL RENOVATION NOTES

- A. WORK AREA IS TO BE SECURED AT END OF EACH WORK DAY.
- B. PATCH & REPAIR EXISTING CONSTRUCTION WHERE EXISTING ITEMS ARE REMOVED OR NEW ITEMS ARE INSTALLED TO MATCH ADJACENT EXISTING CONSTRUCTION.
- C. PREPARE ALL EXISTING C.M.U. WALLS TO RECEIVE NEW PAINT IN AREAS INDICATED.
- D. REFER TO MECHANICAL, PLUMBING AND ELECTRICAL DRAWINGS FOR REMOVAL/INSTALLATION OF ITEMS AS REQUIRED.

FLOOR PLAN NOTES

- 1. INSTALL NEW WALL - 3 5/8" MTL. STUD WALLS @ 24" O.C. W/ 5/8" TYPE "X" WALLBOARD EA. SIDE.
- 2. INSTALL NEW DOOR AND FRAME AS REQUIRED.
- 3. INSTALL NEW WALL - 3 5/8" MTL. STUD WALLS @ 24" O.C. W/ 5/8" TYPE "X" WALLBOARD ONE SIDE.
- 4. PROVIDE SOUND ATTENUATION INSULATION IN WALLS.
- 5. INSTALL NEW DOOR AND FRAME IN NEW OPENING IN EXISTING WALL. SCAN WALL FOR EXISTING REBAR LOCATIONS. LOCATE DOOR BETWEEN EXISTING VERTICAL REINFORCING. CONSTRUCT NEW DOOR OPENING PER STRUCTURAL DETAIL T1AP.2.
- 6. INSTALL PADDING ON ALL WALL AND DOOR SURFACES UP TO 8'-0" A.F.F.
- 7. INSTALL NEW FIRE EXTINGUISHER CABINET

WALL SYMBOLS LEGEND

- [Symbol] EXISTING C.M.U. WITH BRICK VENEER EXTERIOR WALL TO REMAIN
- [Symbol] EXISTING C.M.U. WITH BRICK VENEER EXTERIOR WALL TO REMAIN
- [Symbol] EXISTING 1-HOUR C.M.U. WALL SEALED TIGHT TO BOTTOM OF DECK
- [Symbol] EXISTING 2-HOUR C.M.U. WALL SEALED TIGHT TO BOTTOM OF DECK
- [Symbol] EXISTING 4-HOUR C.M.U. WALL SEALED TIGHT TO BOTTOM OF DECK
- [Symbol] EXISTING C.M.U. WALL SEALED TIGHT TO BOTTOM OF DECK TO REMAIN
- [Symbol] EXISTING C.M.U. WALL - EXTENDED 4" ABOVE CEILING
- [Symbol] EXISTING SMOKE BARRIER C.M.U. WALL SEALED TIGHT TO BOTTOM OF DECK
- [Symbol] 30 MINUTES C.M.U. WALL SEALED TIGHT TO BOTTOM OF DECK
- [Symbol] EXISTING C.M.U. WALL TO BE REMOVED
- [Symbol] EXISTING METAL STUD WALL WITH 5/8" TYPE "X" GYP. BD. EACH SIDE RUN 4" ABOVE CEILING
- [Symbol] EXISTING SMOKE BARRIER METAL STUD WALL WITH 5/8" TYPE "X" GYP. BD. EACH SIDE SEALED TIGHT TO BOTTOM OF DECK.
- [Symbol] NEW METAL STUD WALL WITH 5/8" TYPE "X" GYP. BD. EACH SIDE W/SOUND INSULATION
- [Symbol] NEW METAL STUD WALL WITH 5/8" TYPE "X" GYPSUM BOARD ON ONE OR BOTH SIDES


\* EXTEND ALL NEW WALLS TIGHT TO DECK ABOVE AND FILL BETWEEN FLUTES OF METAL DECK, UNLESS OTHERWISE NOTED.

REFLECTED CEILING PLAN LEGEND

- [Symbol] EXISTING LAY-IN ACOUSTICAL TILE CEILING TO REMAIN
- [Symbol] EXISTING LAY-IN ACOUSTICAL TILE CEILING TO BE REMOVED
- [Symbol] NEW LAY-IN ACOUSTICAL TILE CEILING
- [Symbol] NEW GYPSUM BOARD BULKHEAD
- [Symbol] EXISTING RECESSED 2 X 4 FIXTURE TO REMAIN
- [Symbol] EXISTING RECESSED 2 X 4 FIXTURE TO BE REMOVED
- [Symbol] NEW RECESSED 2 X 4 FIXTURE
- [Symbol] EXISTING EXIT LIGHT TO REMAIN
- [Symbol] EXISTING EXIT LIGHT TO BE REMOVED
- [Symbol] NEW EXIT LIGHT
- [Symbol] EXISTING HVAC DEVICES TO REMAIN
- [Symbol] EXISTING HVAC DEVICES TO BE REMOVED
- [Symbol] NEW SUPPLY AIR DIFFUSER/EXHAUST GRILLE
- [Symbol] EXIST. CAMERA/NEW CAMERA - CLG. MT. (O.F.O.I.)
- [Symbol] EXIST. CAMERA/NEW CAMERA - WALL MT. (O.F.O.I.)
- [Symbol] EXISTING CEILING-MOUNTED SPEAKER TO BE REMOVED
- [Symbol] NEW CEILING-MOUNTED SPEAKER
- [Symbol] EXISTING SMOKE DETECTOR TO BE REMOVED
- [Symbol] NEW SMOKE DETECTOR
- [Symbol] NEW UNIT HEATER
- [Symbol] SPRINKLER HEAD - EXISTING
- [Symbol] SPRINKLER HEAD - NEW (NOTE: PROPOSED LOCATIONS SHOWN FOR COORDINATION PURPOSES ONLY)

REFLECTED CEILING PLAN NOTES

- GENERAL: REMOVE / REPLACE CEILING GRID AND TILE AS REQUIRED BY INSTALLATION OF NEW HVAC SYSTEM AND NEW SPRINKLER EXTENSION. REPLACE ANY DAMAGED GRID AND / OR TILE WITH NEW.
- 7. INSTALL NEW CEILING - ALIGN WITH EXISTING CEILING GRID AND TILE TO REMAIN.
- 8. REINSTALL EXISTING LIGHTING IN NEW LOCATIONS INDICATED. SEE ELECTRICAL.
- 9. INSTALL NEW HVAC DEVICES - SEE MECHANICAL.
- 10. INSTALL NEW ILLUMINATED EXIT SIGNS.
- 11. RELOCATE OR ADD SPRINKLER HEADS AS REQUIRED. SEE FIRE PROTECTION PLANS.

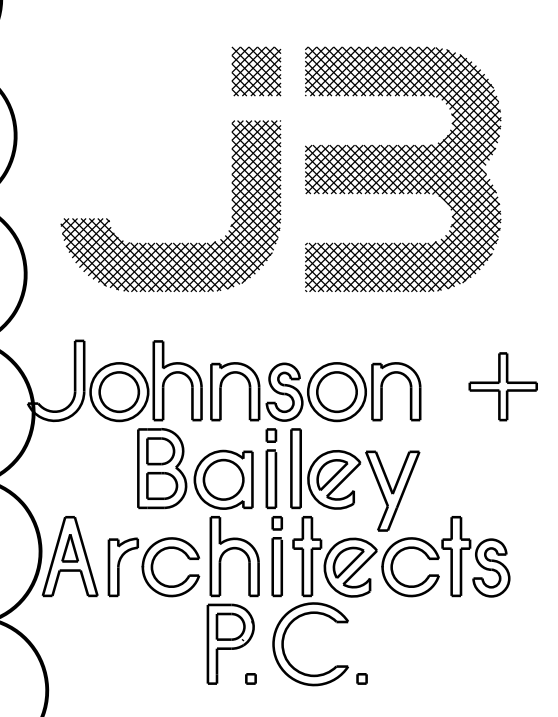

City Center  
100 East Vine St.  
Murfreesboro Tennessee  
37130  
615-890-4560  
Fax: 615-890-4564


Special Education  
Alterations to  
Centennial  
High School

Williamson County Schools


| REVISION       | DATE     |
|----------------|----------|
| 1. ADDENDUM #1 | 05-04-26 |

NOTES:


THIS DRAWING SHALL NOT BE REPRODUCED, PUBLISHED, OR USED IN ANY WAY WITHOUT THE WRITTEN PERMISSION OF THE ARCHITECT.

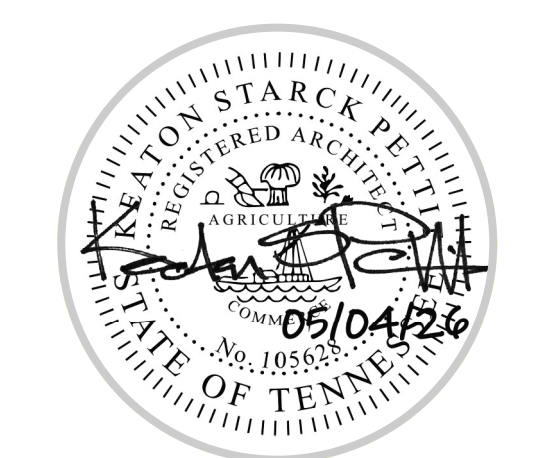


PROJECT NO. 2519  
DATE 03-10-26  
DRAWN BY C.L.C.  
CHECKED BY K.S.P.

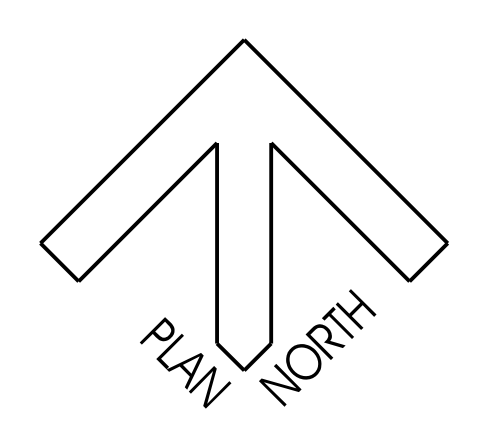


A2.2

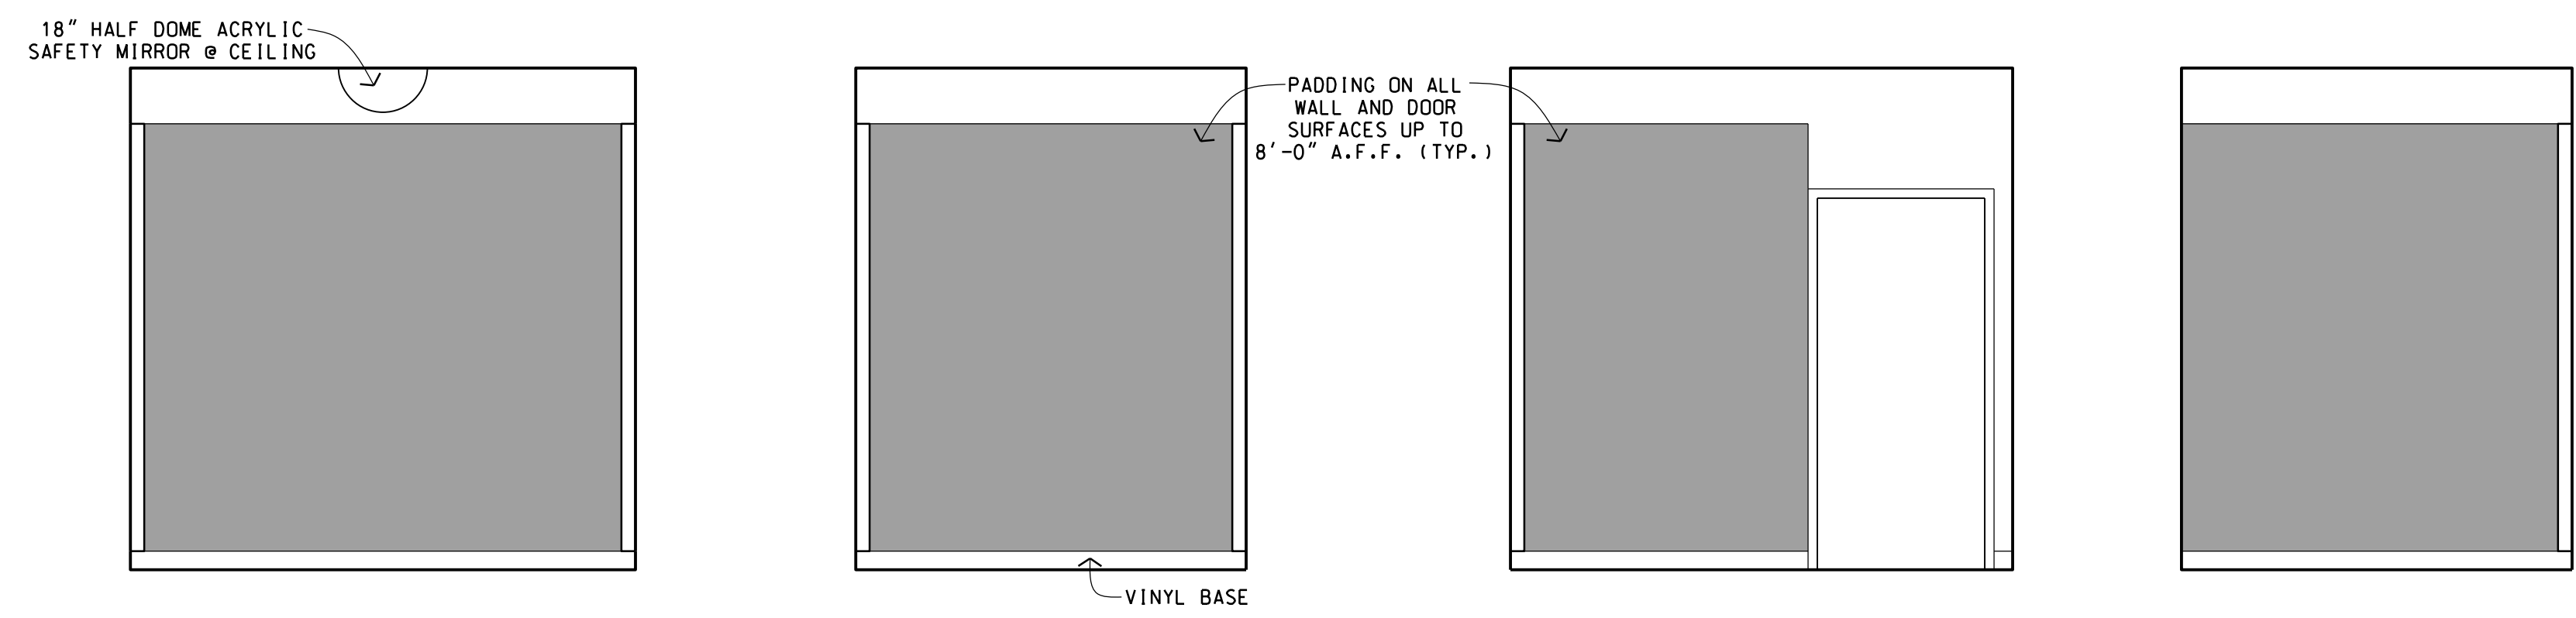

1 CALM ROOM D-10B    2 CALM ROOM D-10B    3 CALM ROOM D-10B    4 CALM ROOM D-10B


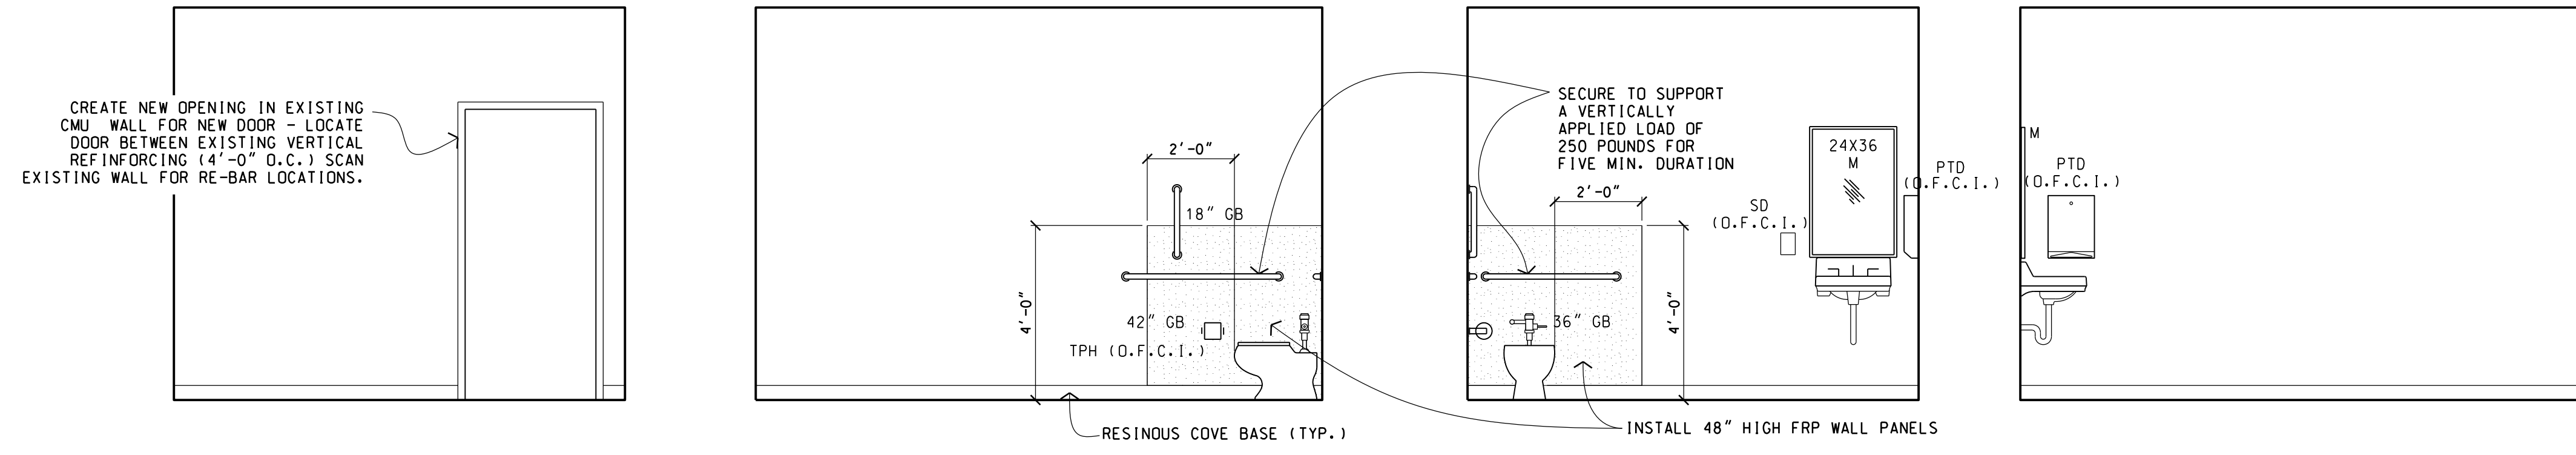


5 TLT. D-18    6 TLT. D-18    7 TLT. D-18    8 TLT. D-18

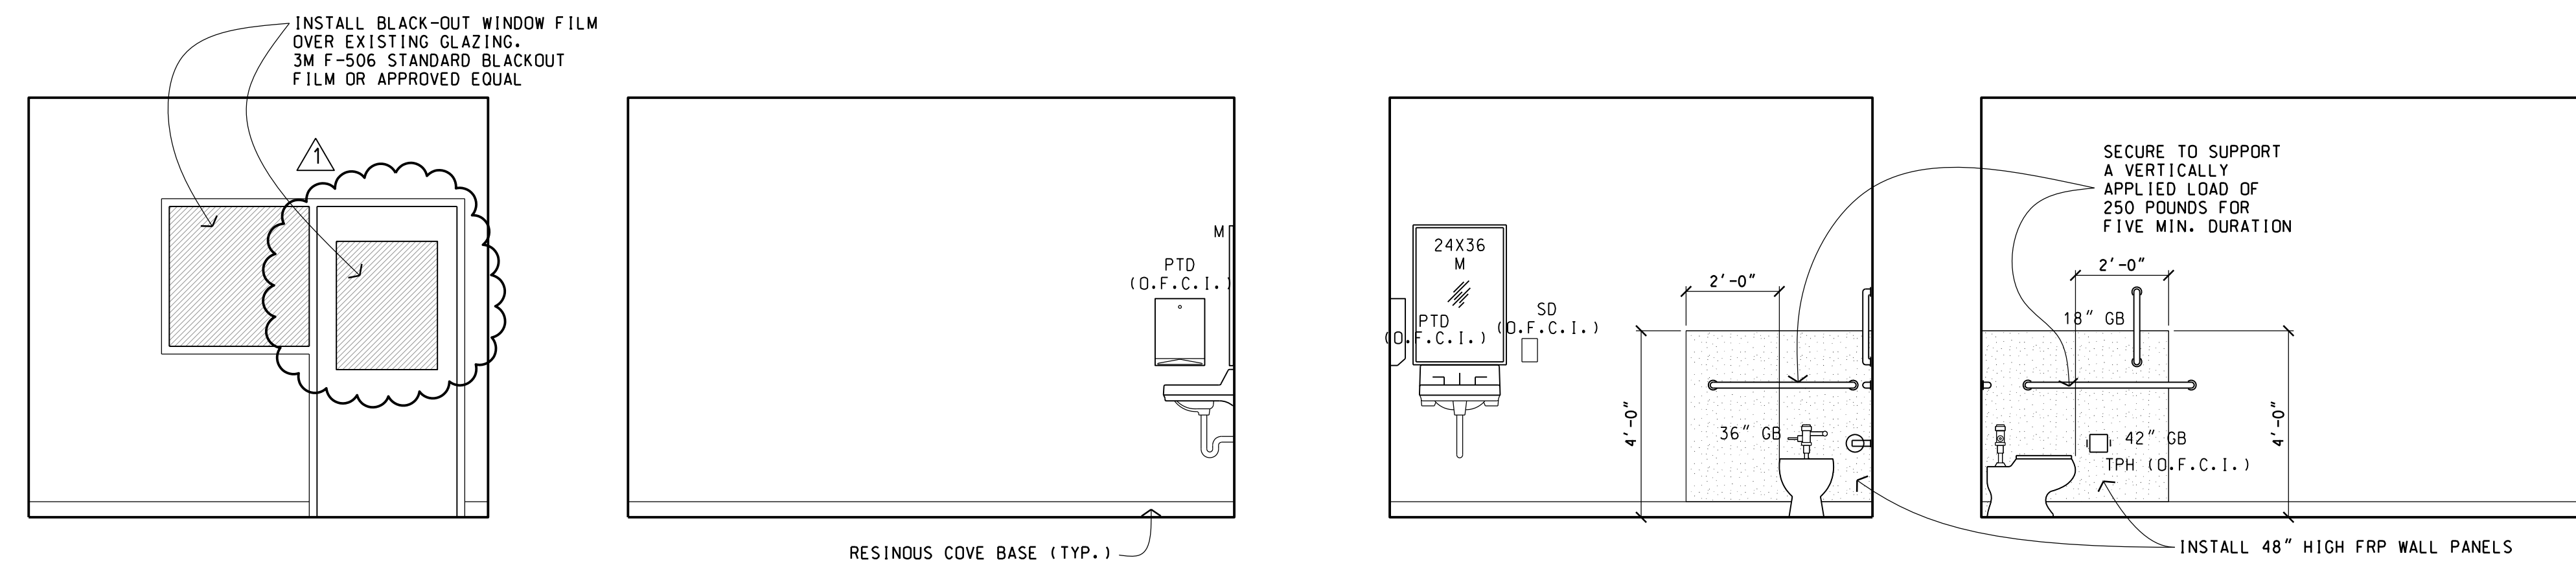


9 TLT. D-19    10 TLT. D-19    11 TLT. D-19    12 TLT. D-19

CALM ROOM & TOILET ELEVATIONS

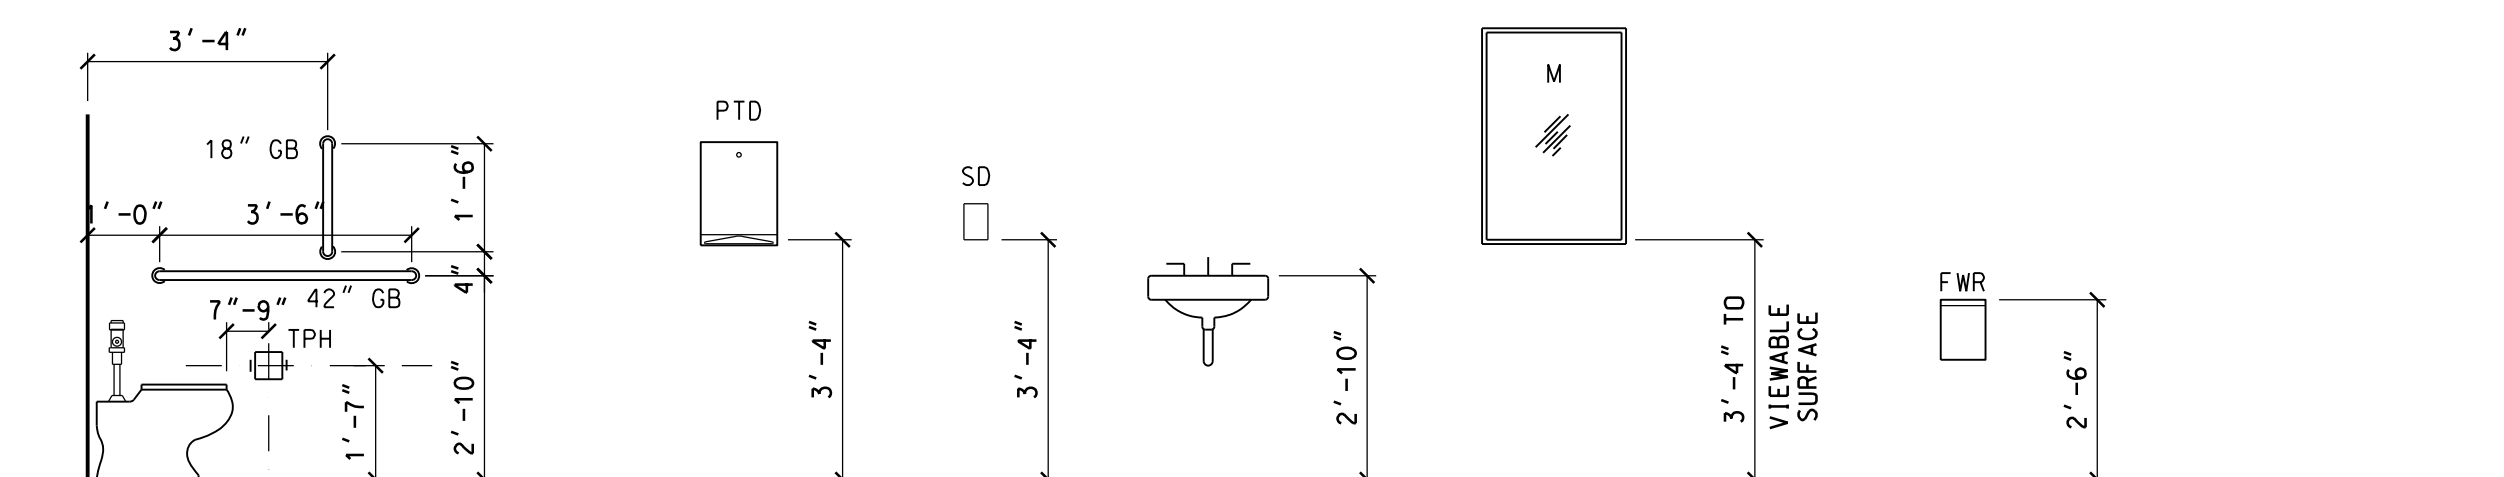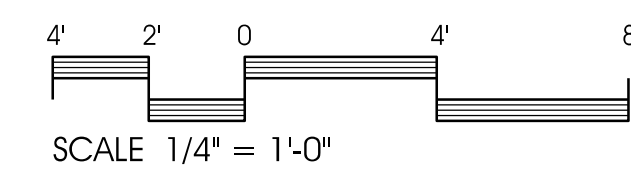

TYPICAL MOUNTING HEIGHTS

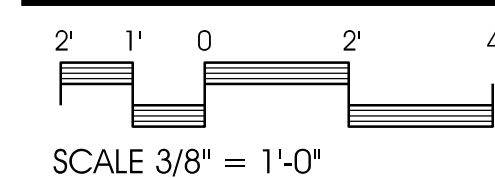

**TOILET/ACCESSORIES ABBREVIATION KEY**

- DF - DRINKING FOUNTAIN
- FWR - FEMININE WASTE RECEPTACLE
- GB - GRAB BAR
- HC - HANDICAP
- M - MIRROR
- RB - RUBBER BASE
- MBH - MOP & BROOM HOLDER
- N.I.C. - NOT IN CONTRACT
- PTD - PAPER TOWEL DISPENSER (N.I.C.)
- SD - SOAP DISPENSER (N.I.C.)
- TPH - TOILET PAPER HOLDER (N.I.C.)
- U.O.N. - UNLESS OTHERWISE NOTED
- O.F.C.I. - OWNER FURNISHED CONTRACTOR INSTALLED

| INTERIOR FINISH SCHEDULE |            |       |      |          |       |       |      |         |                |                  |    |    |         |         |
|--------------------------|------------|-------|------|----------|-------|-------|------|---------|----------------|------------------|----|----|---------|---------|
| SPACE NUMBER             | SPACE NAME | FLOOR | BASE | WAINSCOT | WALLS |       |      | CEILING | CEILING HEIGHT | PAINTED SURFACES |    |    | REMARKS |         |
|                          |            |       |      |          | WEST  | NORTH | EAST |         |                | WALLS            |    |    |         | CEILING |
|                          |            |       |      |          |       |       |      |         |                | W                | N  | S  |         |         |
| FLOOR PLAN - PART A      |            |       |      |          |       |       |      |         |                |                  |    |    |         |         |
| D-10B                    | CALM ROOM  | EX    | VL   |          | GW    | EX    | EX   | GW      | AT             | MATCH EXISTING   | PT | PT | PT      |         |
| D-18                     | TOILET     | RF    | RF   |          | EX    | EX    | GW   | GW      | AT             | MATCH EXISTING   | PT | PT | PT      |         |
| D-19                     | TOILET     | RF    | RF   |          | GW    | EX    | EX   | GW      | AT             | MATCH EXISTING   | PT | PT | PT      |         |

**FINISH SCHEDULE ABBREVIATIONS**

AT - ACUSTICAL TILE CEILING (RATED)  
 EX - EXISTING TO REMAIN  
 GW - Gypsum WALLBOARD  
 PT - PAINT  
 RB - RESINUS FLOORING/COVE BASE  
 VL - VINYL BASE

**FINISH SCHEDULE GENERAL NOTES**

A. INTERIOR WALL AND CEILING FINISHES SHALL COMPLY WITH ASTM E 84 OR UL 725 CLASS A, B, OR C  
 B. INTERIOR FLOOR FINISHES SHALL COMPLY WITH DOC FF-1 "FILL TEST" (PASC 16 OR PART TEST) OR WITH ASTM D 2893.  
 C. PAINT EXISTING HOLLOW METAL DOOR FRAMES AND WINDOW FRAMES WHERE OCCURS.



City Center  
 100 East Vine St.  
 Murfreesboro Tennessee  
 37130  
 615-890-4560  
 Fax: 615-890-4564


Special Education Alterations to Centennial High School

Williamson County Schools

| REVISION      | DATE     |
|---------------|----------|
| 1 ADDENDUM #1 | 05-04-26 |

NOTES:

THIS DRAWING SHALL NOT BE REPRODUCED, PUBLISHED, OR USED IN ANY WAY WITHOUT THE WRITTEN PERMISSION OF THE ARCHITECT.

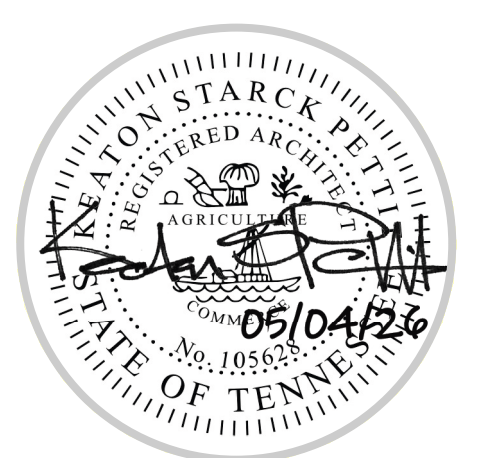

PROJECT NO. 2519  
 DATE 03-10-26  
 DRAWN BY C.L.C.  
 CHECKED BY K.S.P.




NOTES:

THIS DRAWING SHALL NOT BE REPRODUCED, PUBLISHED, OR USED IN ANY WAY WITHOUT THE WRITTEN PERMISSION OF THE ARCHITECT.




PROJECT NO. 2519  
 DATE 03-10-26  
 DRAWN BY C.S.C.  
 CHECKED BY C.S.C.


**M201**

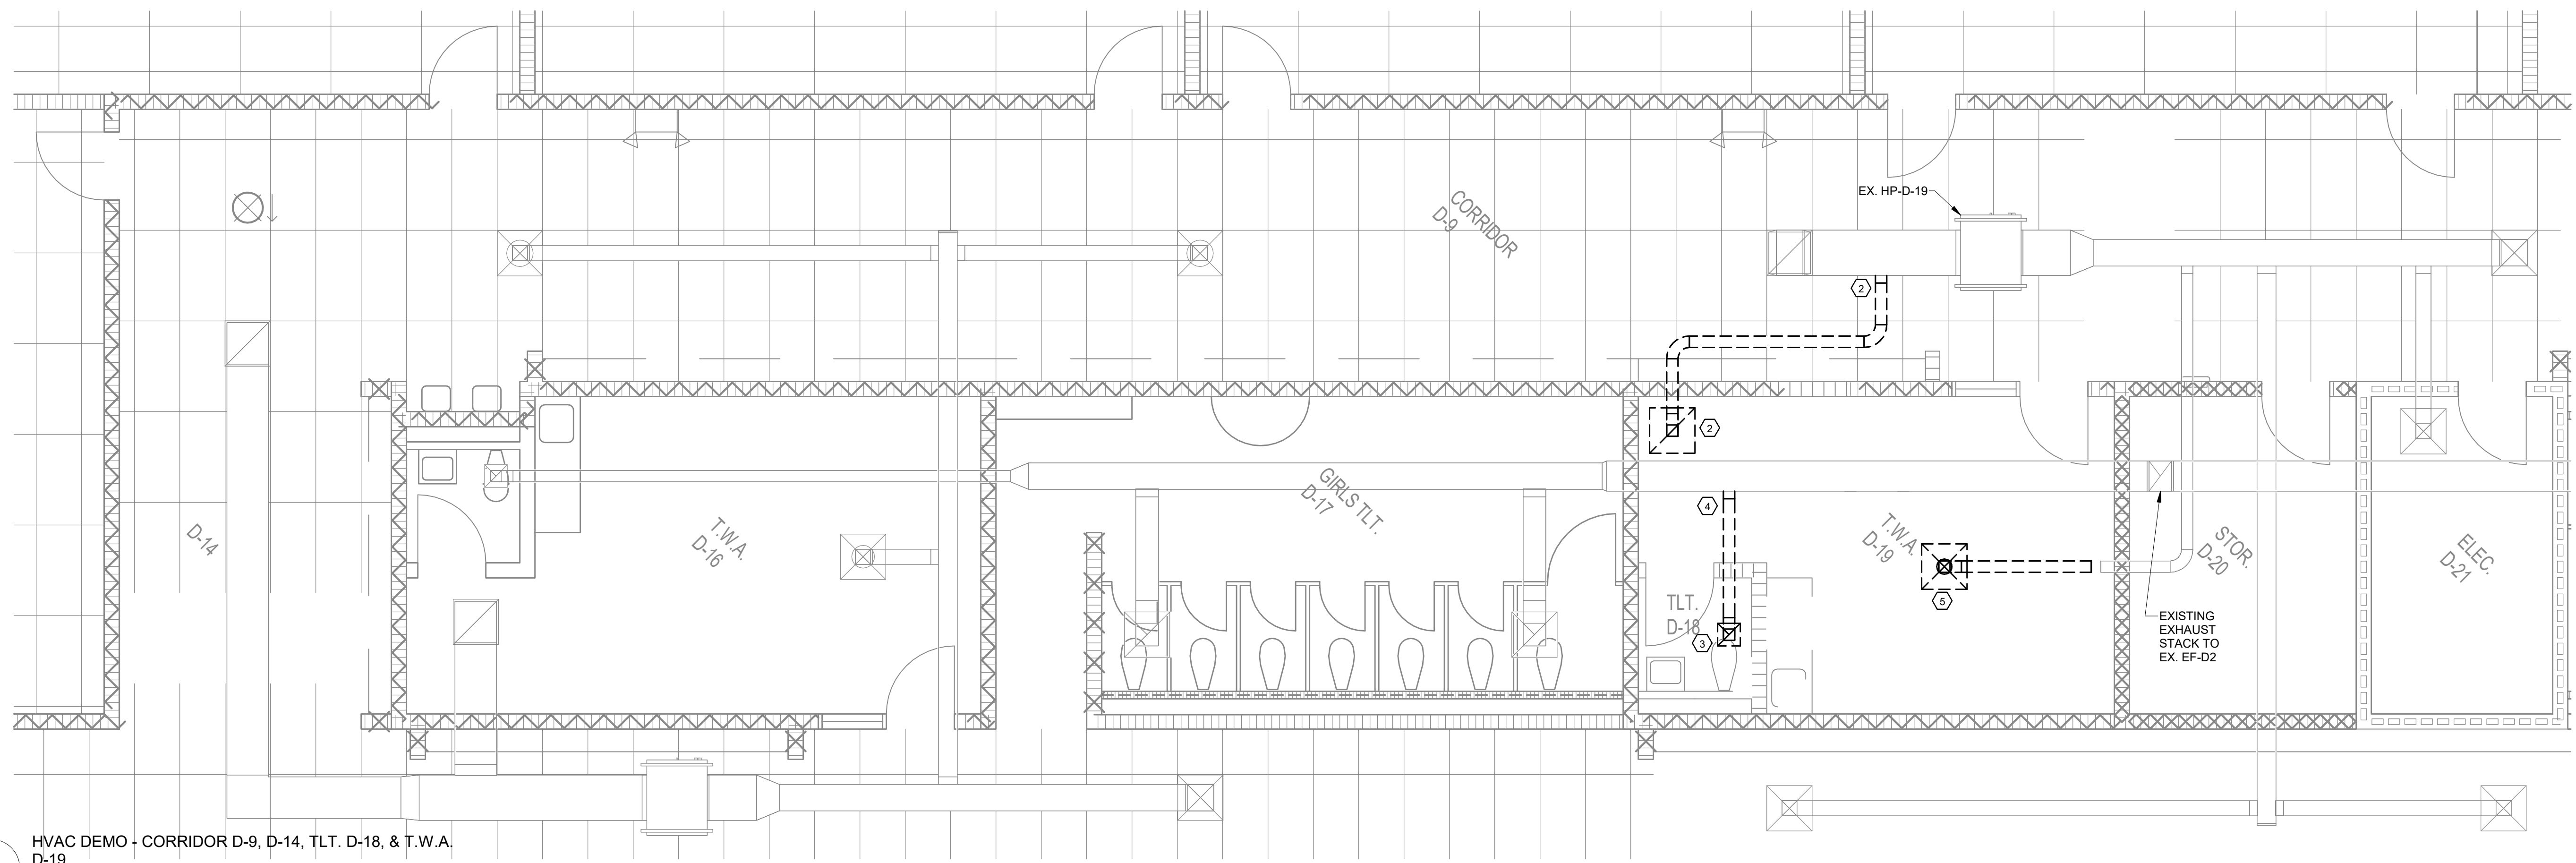

2 HVAC DEMO - CORRIDOR D-9, D-14, TLT. D-18, & T.W.A. D-19  
 1/4" = 1'-0"

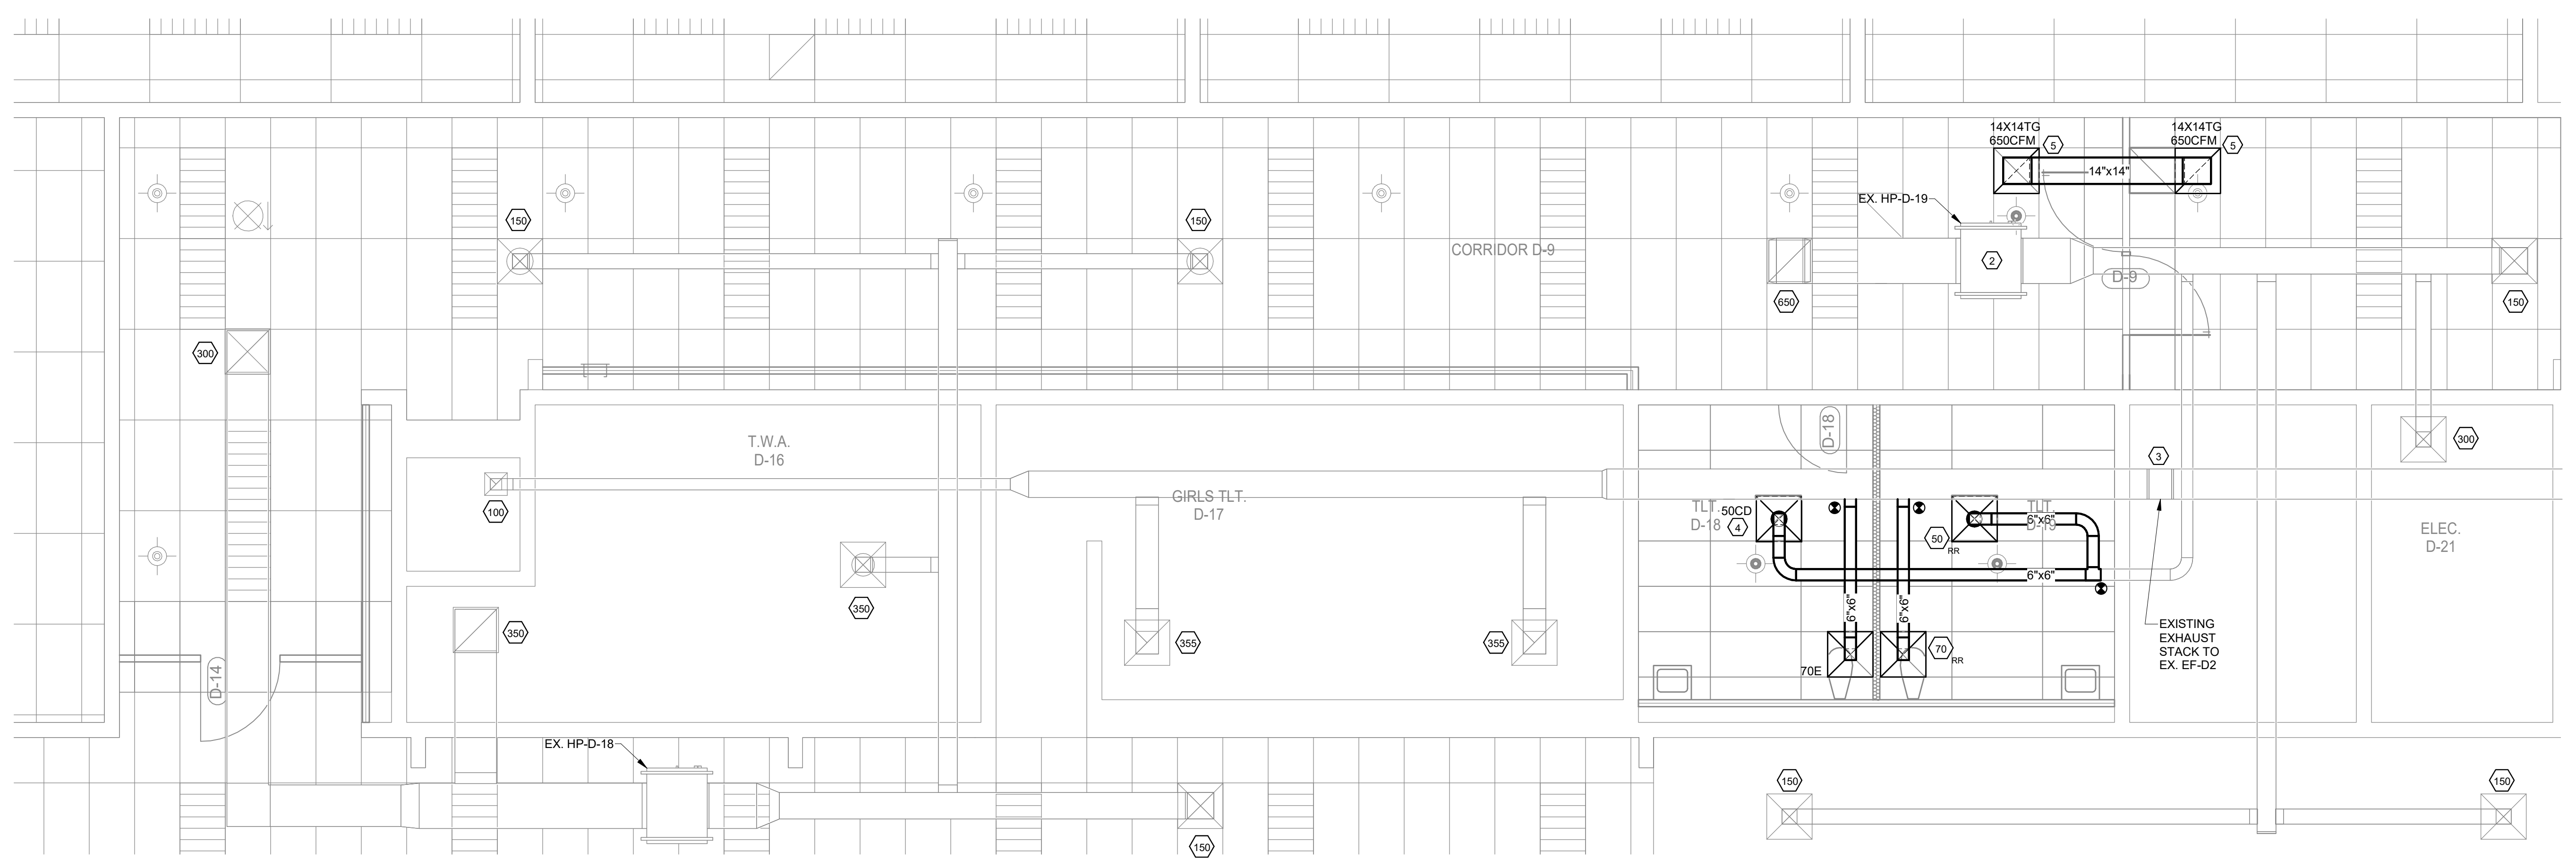

4 HVAC - CORRIDOR D-9, D-14, TLT. D-18, & T.W.A. D-19  
 1/4" = 1'-0"

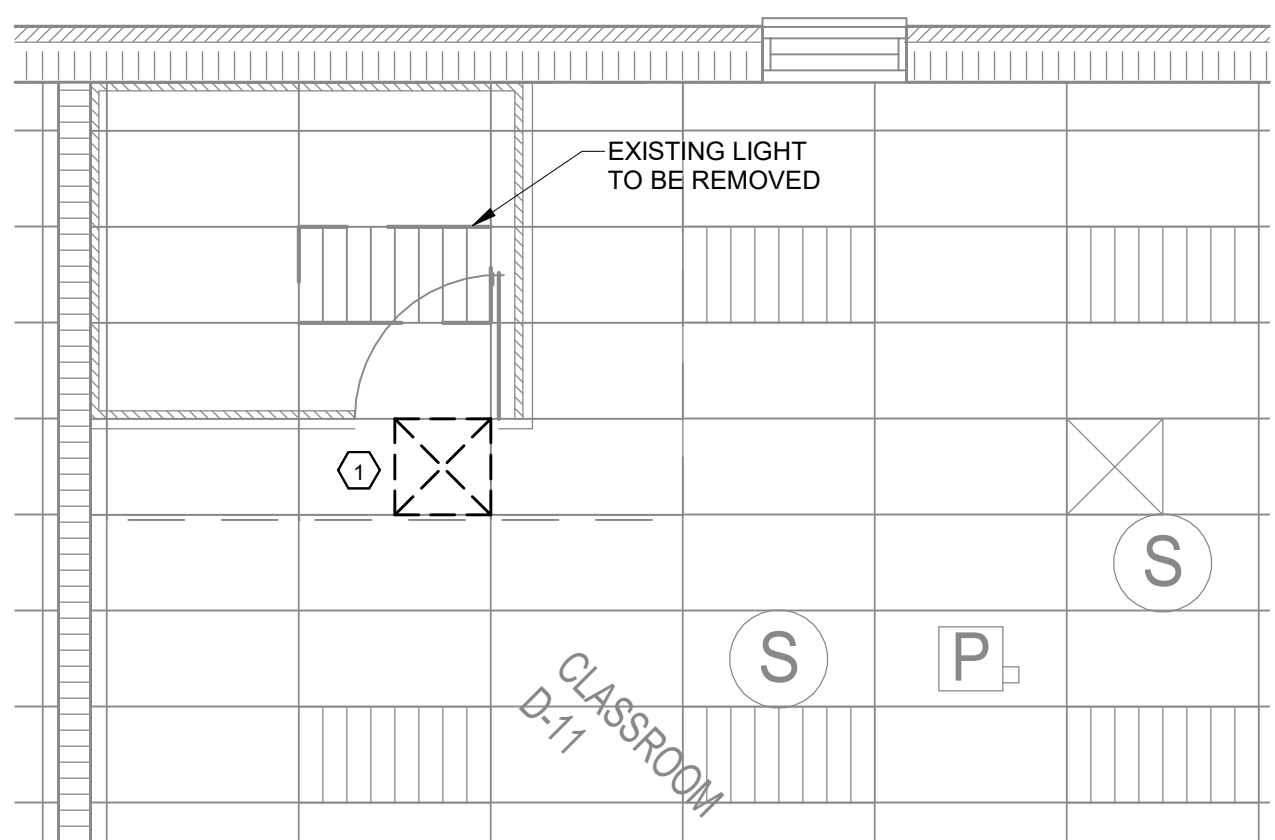


1 HVAC DEMO - CLASSROOM D-10  
 1/4" = 1'-0"

**DEMOLITION LEGEND**

| TYPE | DESCRIPTION                    |
|------|--------------------------------|
| ---  | EXISTING WORK TO REMAIN        |
| ---- | EXISTING WORK TO BE DEMOLISHED |

**HVAC KEYED NOTES**

- EXISTING CEILING DIFFUSER & DAMPER TO BE RELOCATED. STORE DIFFUSER UNTIL REINSTALLED. CLEAN & REPAINT ANY BLEMISHES.
- DEMO EXISTING RETURN GRILLE AND BRANCH DUCTING. SEAL BRANCH TAP AT MAIN.
- DEMO EXHAUST BRANCH DUCT. SEAL BRANCH TAP AT MAIN.
- EXISTING EXHAUST GRILLE TO BE RELOCATED. STORE GRILLE UNTIL REINSTALLED. CLEAN & REPAINT ANY BLEMISHES.
- EXISTING DIFFUSER & DAMPER TO BE RELOCATED. STORE DIFFUSER UNTIL REINSTALLED. CLEAN & REPAINT ANY BLEMISHES.

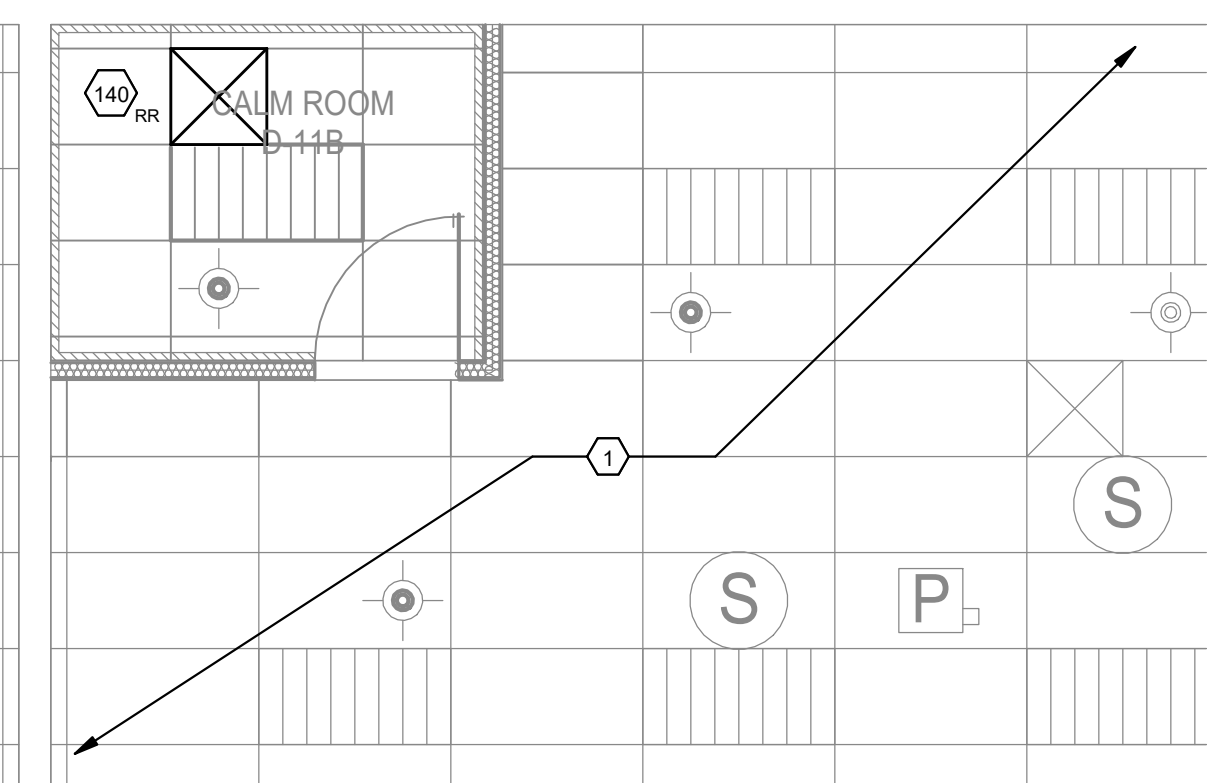


3 HVAC - CLASSROOM D-11  
 1/4" = 1'-0"

**NEW WORK LEGEND**

| TYPE   | DESCRIPTION                               |
|--------|---|
| ---    | EXISTING WORK TO REMAIN                   |
| ---    | NEW WORK                                  |
| ⊕      | CONNECTION TO EXISTING                    |
| 100    | REBALANCE EXISTING TO AIRFLOW SHOWN       |
| 100/RR | RELOCATE & REBALANCE EX. TO AIRFLOW SHOWN |

**HVAC KEYED NOTES**



- REBALANCE EACH OF THE THREE REMAINING DIFFUSERS IN CLASSROOM D-10 TO 420 CFM.
- REBALANCE EX. HP-D19 WATER FLOW TO 6.5 GPM.
- REBALANCE EX. EF-D2 TOTAL DISCHARGE TO 2,750 CFM.
- PROVIDE CEILING DIFFUSER WITH FUSIBLE FIRE DAMPER EQUAL TO PRICE SMD-FR.
- PROVIDE CEILING MOUNTED TRANSFER GRILLES WITH FUSIBLE FIRE DAMPER EQUAL TO PRICE 81FR.

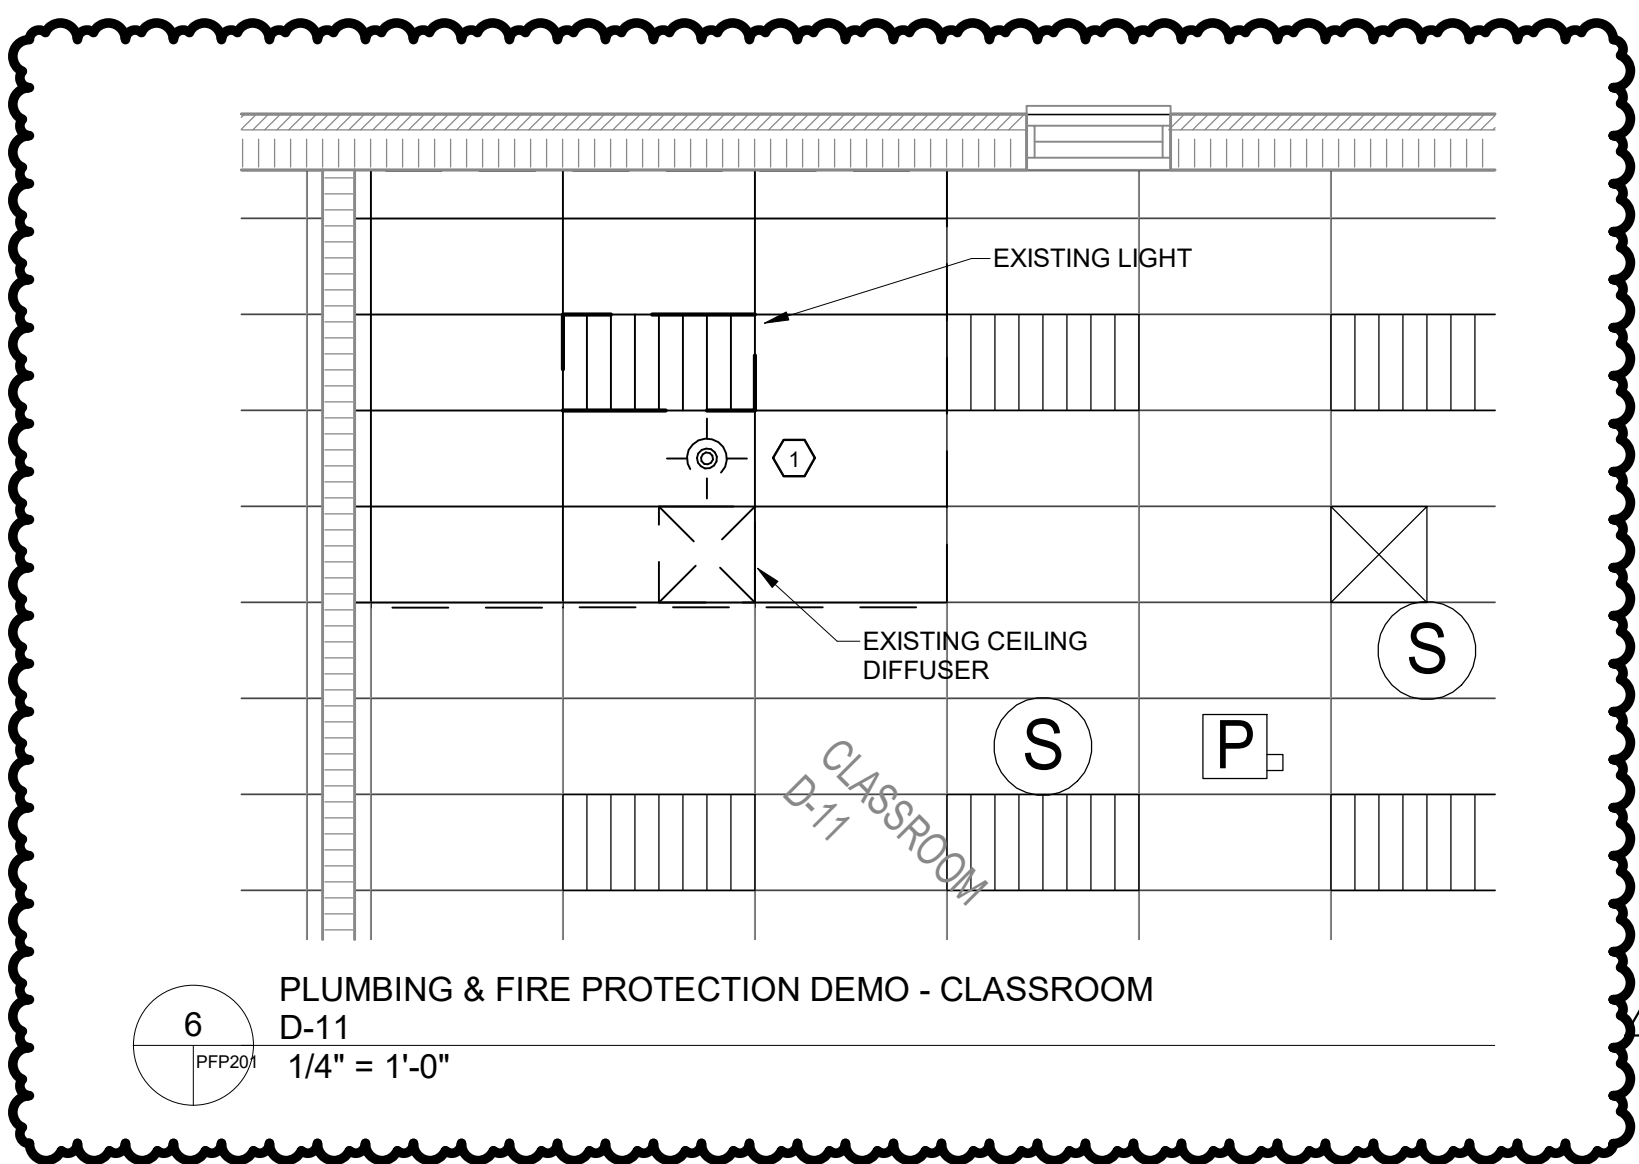

- PLUMBING DEMO GENERAL NOTES**
- IN AREA SHOWN, ALL PLUMBING EQUIPMENT, FIXTURES, PIPING, ETC., REQUIRED TO BE REMOVED TO ALLOW FOR NEW CONSTRUCTION, ABANDONED AS A RESULT OF NEW CONSTRUCTION. OR CURRENTLY NOT IN SERVICE SHALL BE REMOVED AS PART OF THIS CONTRACT.
  - FOR FIXTURES TO BE RELOCATED: DEMO SANITARY PIPING TO MAIN AND CAP B.F.F. REFINISH FLOOR SMOOTH & LEVEL WITH SURROUNDINGS. DEMO DOMESTIC WATER & VENT PIPING TO ABOVE CEILING AND PREPARE PIPING FOR EXTENSION TO NEW FIXTURE LOCATION.
  - FOR FIXTURES TO BE REMOVED: DEMO SANITARY PIPING TO MAIN AND CAP B.F.F. REFINISH FLOOR SMOOTH & LEVEL WITH SURROUNDINGS. DEMO DOMESTIC WATER BRANCH LINES TO MAIN AND CAP. DEMO VENT PIPING BRANCH LINES TO MAIN AND CAP.
  - OFFER DEMOLISHED FIXTURES & EQUIPMENT TO MAINTENANCE FOR INVENTORY PRIOR TO DISPOSAL.


- PLUMBING & FP DEMO KEYED NOTES**
- EXISTING SPRINKLER HEAD TO BE RELOCATED.
  - DEMO EXISTING LAVATORY. OFFER FIXTURE TO MAINTENANCE PRIOR TO DISPOSAL.
  - DEMO EXISTING WATER CLOSET. OFFER FIXTURE TO MAINTENANCE PRIOR TO DISPOSAL.
  - DEMO EXISTING SINK. OFFER FIXTURE TO MAINTENANCE PRIOR TO DISPOSAL.
  - DEMO DOMESTIC HOT WATER SUPPLY BACK TO MAIN AND CAP.
  - DEMO DOMESTIC HOT WATER RECIRC AS SHOWN.

**1** PLUMBING & FIRE PROTECTION DEMO - CORRIDOR D-9, D-14, TLT. D-18, & T.W.A. D-19  
 1/4" = 1'-0"

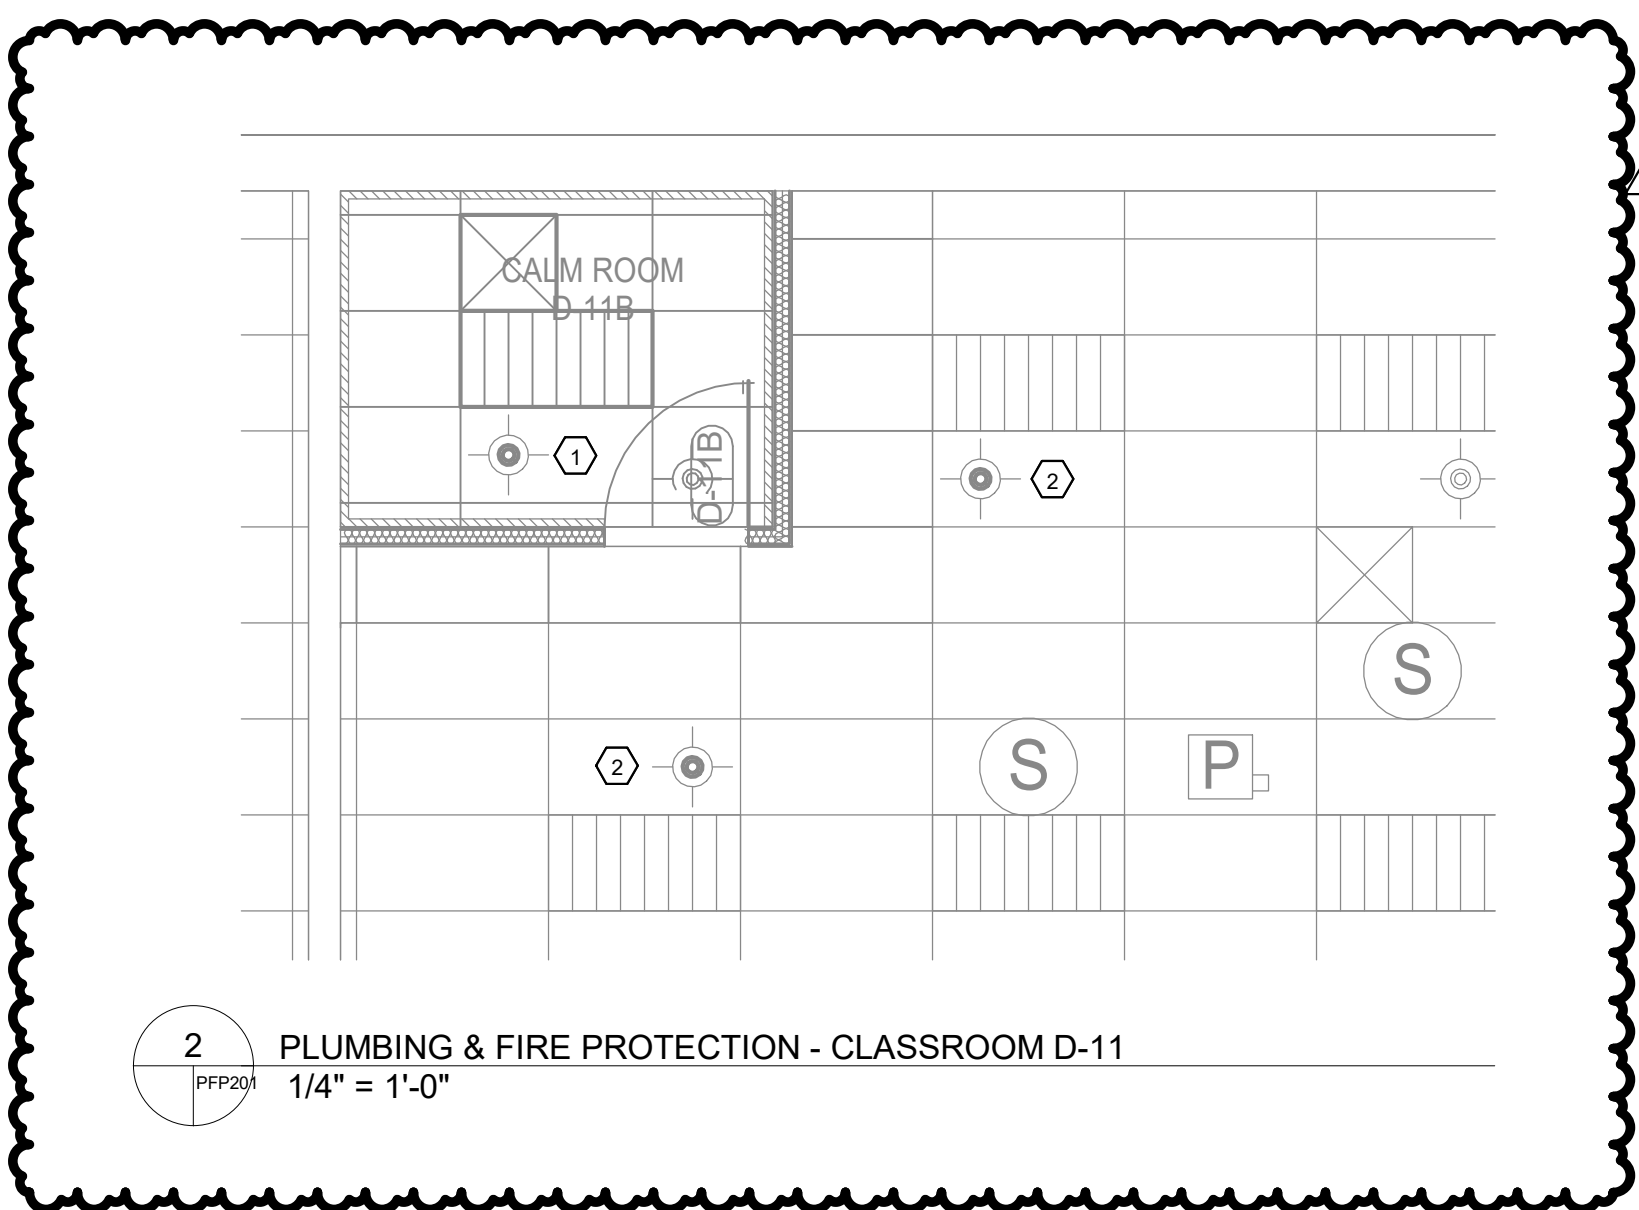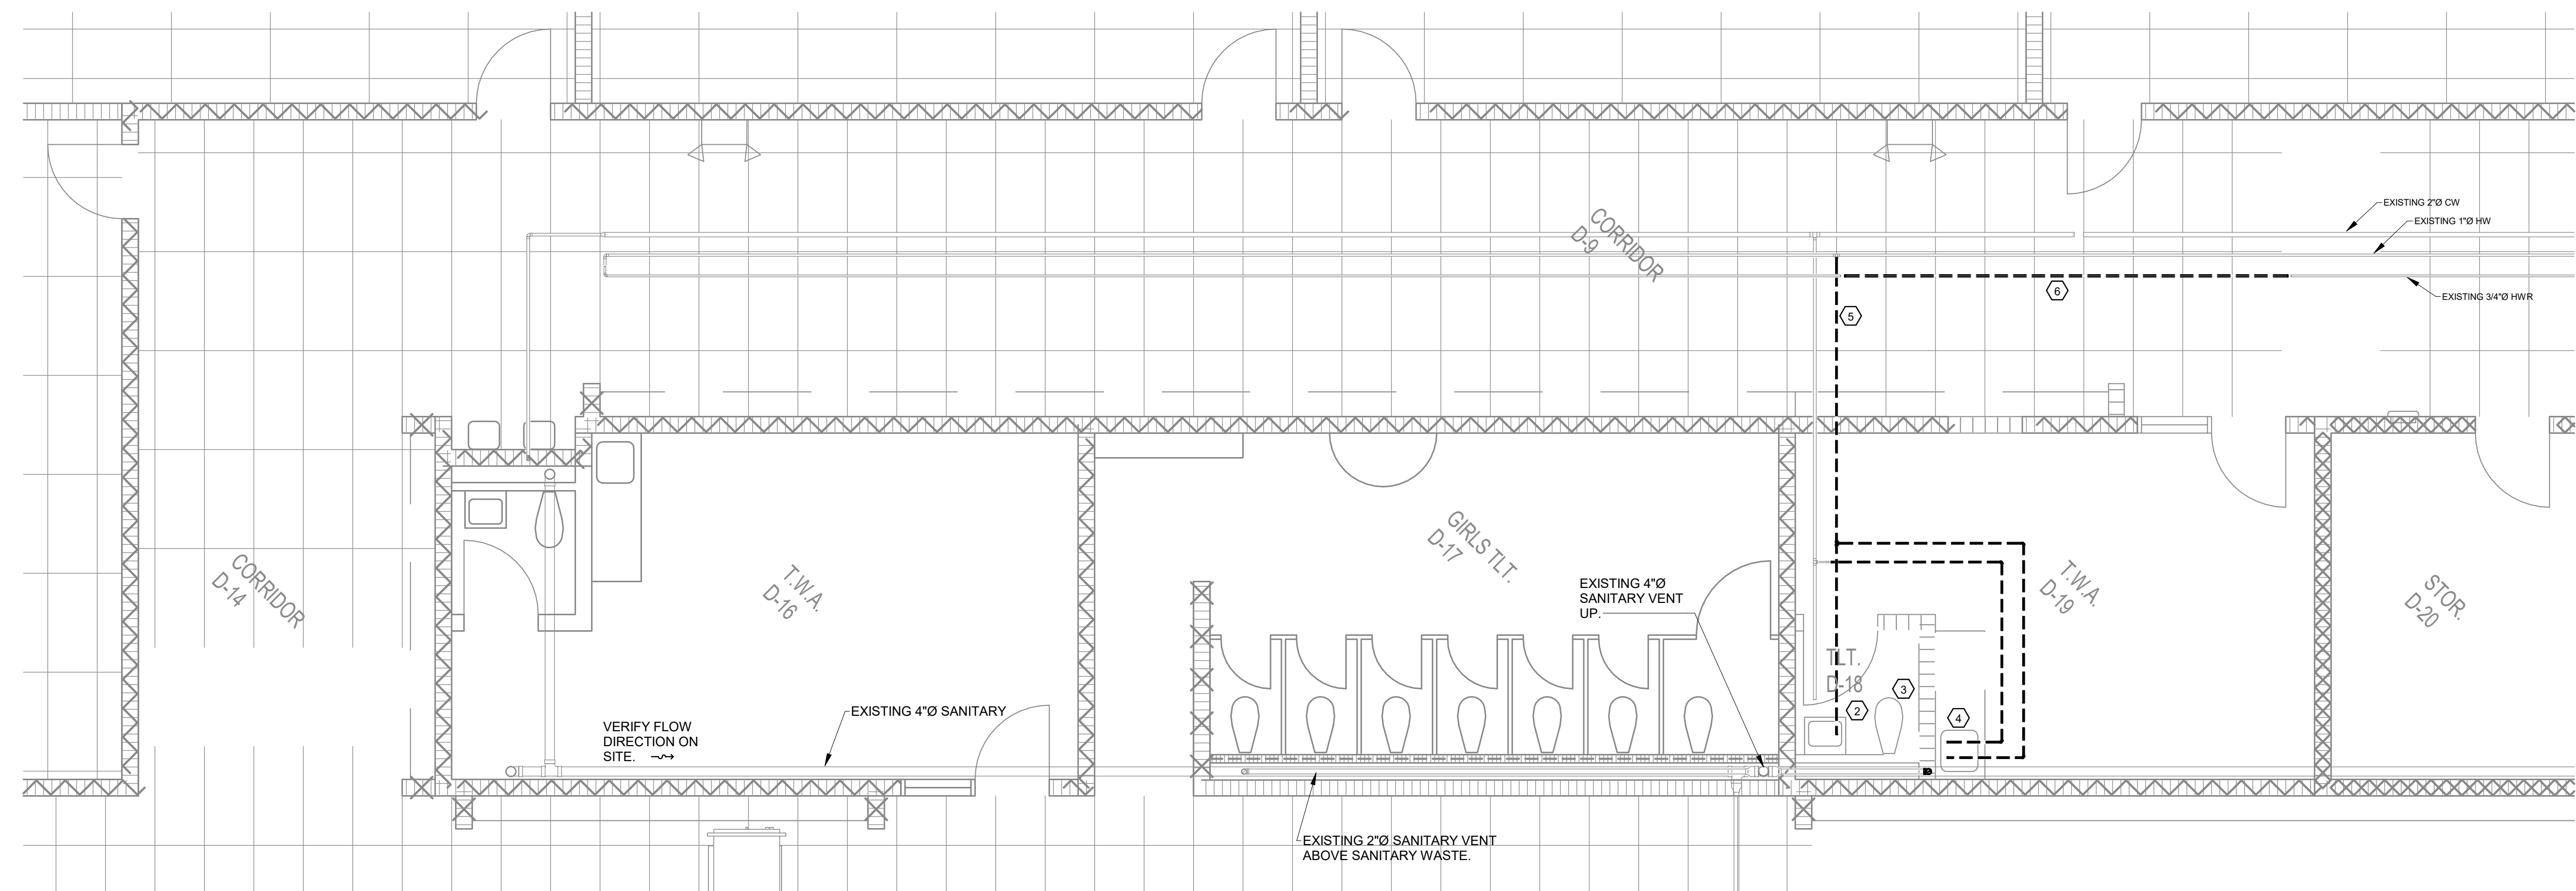

- PLUMBING & FP KEYED NOTES**
- RELOCATED SPRINKLER HEAD.
  - NEW SPRINKLER HEADS. EXACT LOCATION TO BE DETERMINED BY SPRINKLER CONTRACTOR.

**3** PLUMBING & FIRE PROTECTION - CORRIDOR D-9, D-14, TLT. D-18, & T.W.A. D-19  
 1/4" = 1'-0"

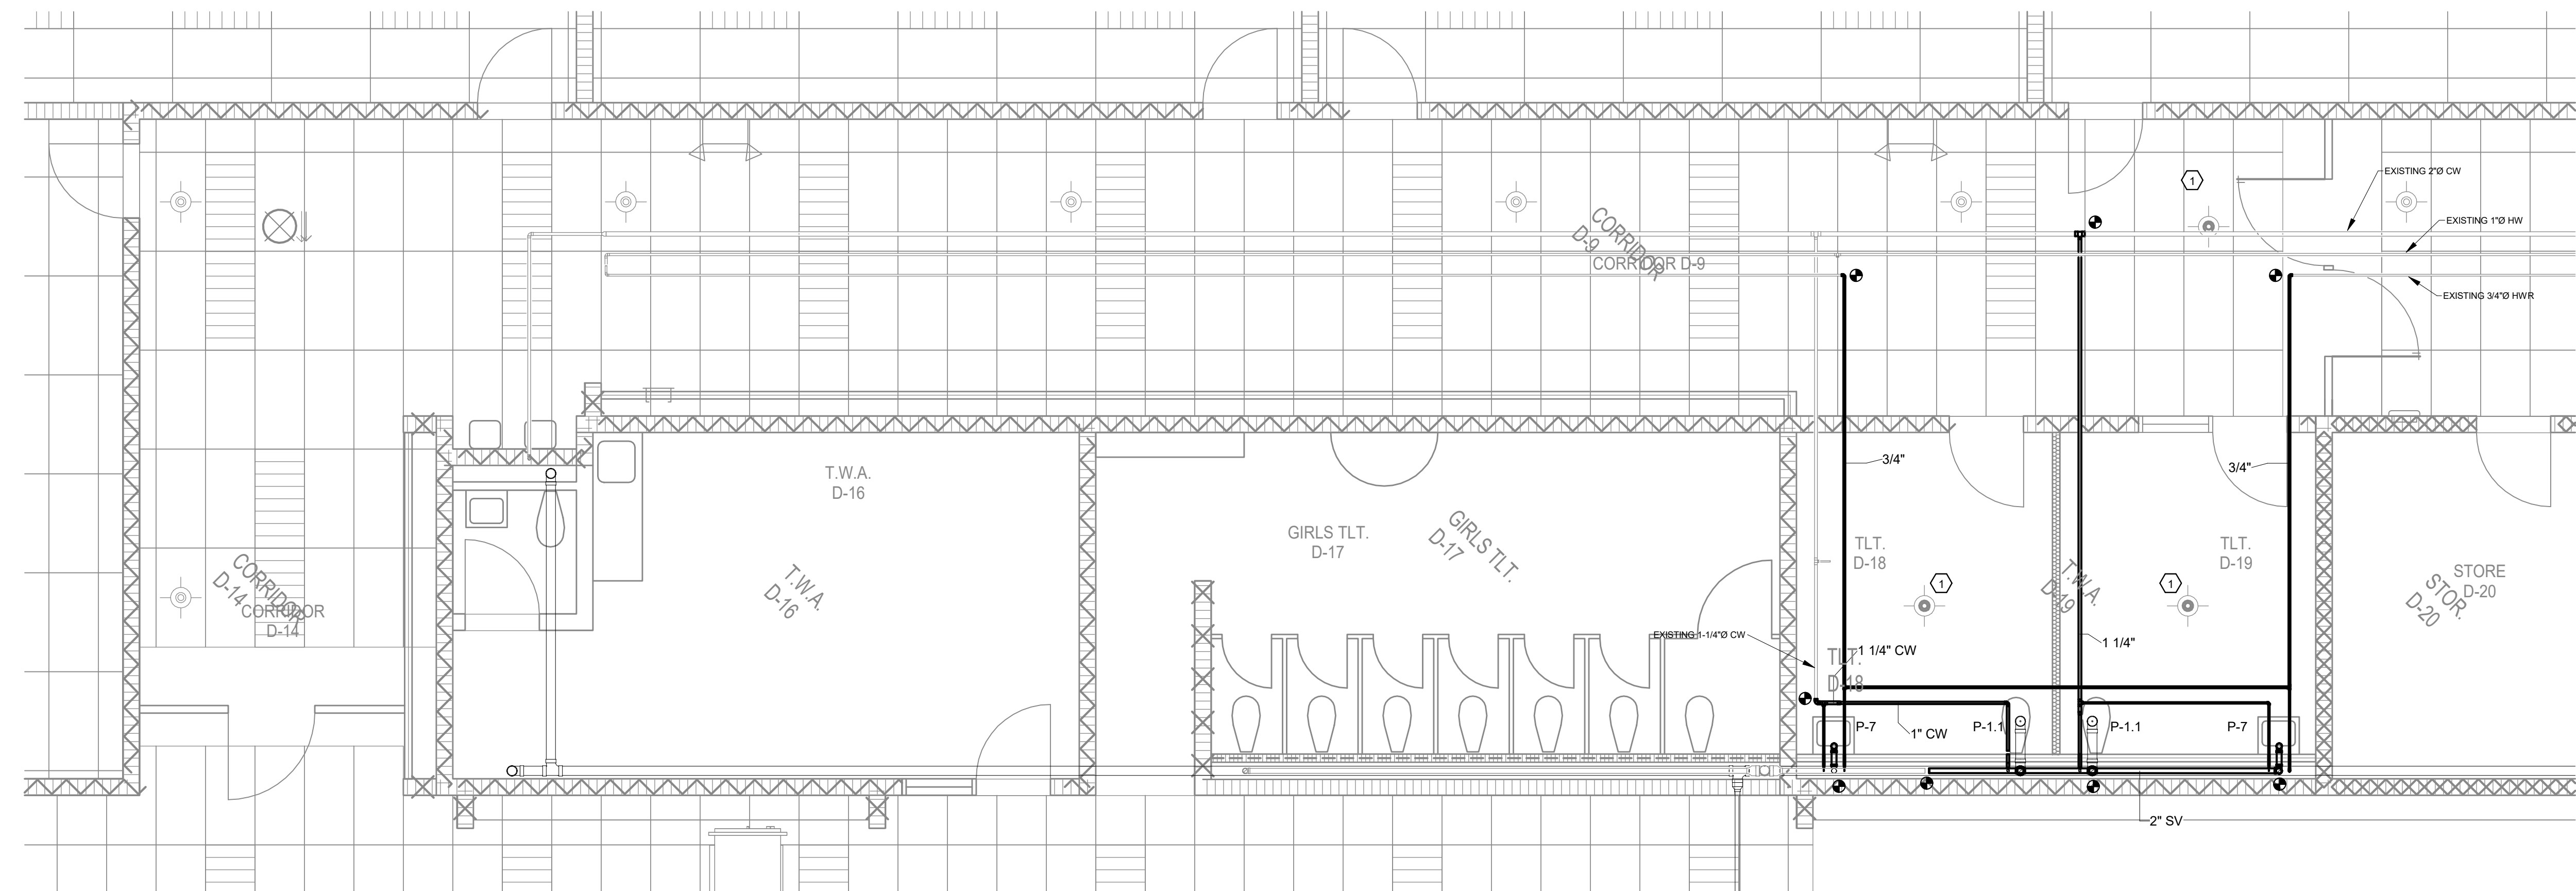

**Special**  
**Education**  
**Alterations to**  
**Centennial**  
**High School**

Williamson County Schools

| REVISION   | DATE     |
|------------|----------|
| Addendum 1 | 5/4/2026 |

NOTES:

THIS DRAWING SHALL NOT BE  
 REPRODUCED, PUBLISHED, OR USED  
 IN ANY WAY WITHOUT THE WRITTEN  
 PERMISSION OF THE ARCHITECT.





PROJECT NO. 2519  
 DATE 03-10-26  
 DRAWN BY C.S.C.  
 CHECKED BY C.S.C.


**E101**

- ELECTRICAL DEMO GENERAL NOTES**
- IN AREA SHOWN, ALL ELECTRICAL EQUIPMENT, CONDUIT, WIRING, DEVICES, FIXTURES, ETC., REQUIRED TO BE REMOVED TO ALLOW FOR NEW CONSTRUCTION, ABANDONED AS A RESULT OF NEW CONSTRUCTION, OR CURRENTLY NOT IN SERVICE SHALL BE REMOVED AS PART OF THIS CONTRACT.
  - EXPOSED CONDUITS AND CONDUITS IN ACCESSIBLE AREAS SHALL BE REMOVED COMPLETELY. CONDUITS CONCEALED IN FLOORS, WALLS AND ABOVE NON-ACCESSIBLE CEILINGS MAY BE CAPPED AND ABANDONED AFTER REMOVAL OF ALL CONDUCTORS. CONDUIT FEEDING EQUIPMENT FROM ABOVE DROPPED CEILING TO BE DISCONNECTED AND REMOVED BACK TO SOURCE. DAMAGE TO CEILINGS TO BE REPLACED OR REPAIRED TO MATCH EXISTING. CONTRACTOR TO MAINTAIN THE INTEGRITY OF ALL EXISTING FEED-THROUGH CIRCUITRY WHERE EXISTING ELECTRICAL EQUIPMENT HAS BEEN REMOVED FROM MIDPOINT OF CIRCUIT. NEW WIRE TO BE PULLED THE ENTIRETY OF CIRCUIT.
  - EXISTING ELECTRICAL EQUIPMENT AND CIRCUITRY NOT BEING REMOVED, OR REWORKED UNDER THIS CONTRACT, BUT LOCATED SO AS TO BE AFFECTED BY THE WORK UNDER THIS CONTRACT, SHALL REMAIN IN SERVICE. SUCH CIRCUITS, EQUIPMENT, ETC., SHALL BE EXTENDED, RELOCATED OR REMOVED AND REINSTALLED AS REQUIRED TO ACCOMMODATE NEW CONSTRUCTION.
  - REMOVE ALL EXISTING CIRCUITS SERVING EQUIPMENT SHOWN TO BE REMOVED UNDER THIS CONTRACT. CIRCUIT BREAKERS IN EXISTING PANELBOARDS ABANDONED AS A RESULT OF DEMOLITION SHALL BE REUSED WHERE AVAILABLE, AND SIZED AS SHOWN ON NEW WORK PLANS, TO SERVE NEW EQUIPMENT.
  - EXISTING CIRCUIT BREAKERS FEEDING EXISTING LIGHTING, RECEPTACLES OR EQUIPMENT, WHERE ENTIRE CIRCUIT HAS BEEN REMOVED, TO BE LABELED "SPARE". REUSE "SPARE" CIRCUIT BREAKERS WHERE NOTED ON DRAWINGS.
  - ALL EXISTING LIGHTING FIXTURES BEING RELOCATED TO BE TAKEN DOWN, CLEANED, BALLASTS, LENSES, AND LAMPS REPLACED AS REQUIRED, AND RELOCATED WHERE SHOWN ON LIGHTING PLANS.
  - CONTRACTOR TO MAINTAIN THE INTEGRITY OF ALL EXISTING CIRCUITRY TO REMAIN.

- ELECTRICAL DEMO KEYED NOTES**
- DEMO EXISTING 2X4 LIGHT. OFFER LIGHT TO MAINTENANCE PRIOR TO DISPOSAL.
  - DEMO EXISTING 1X4 LIGHT. OFFER LIGHT TO MAINTENANCE PRIOR TO DISPOSAL.
  - EXISTING 2X4 LIGHT TO BE RELOCATED. REMOVE & STORE LIGHT FOR RE-INSTALLATION.
  - DEMO EXISTING 2X4 LIGHT ON EMERGENCY POWER. OFFER LIGHT TO MAINTENANCE PRIOR TO DISPOSAL.
  - AT FUTURE QUIET ROOM. DEMO RECEPTACLES AND REMOVE ABANDONED BRANCH WIRING. PROVIDE SOLID FACEPLATE AT REMAINING BACK BOX.
  - EXISTING RECEPTACLE TO REMAIN. PROTECT RECEPTACLE DURING RENOVATION. CLEAN FACE PLATE AND REATTACH UPON COMPLETION.
  - DEMO DATA OUTLET AND POWER RECEPTACLE WITHIN EXISTING T.W.A. D-19 SPACE. PROVIDE SOLID FACE PLATES FOR ALL REMAINING BACK BOXES.
  - IF EXISTING RECEPTACLE IS WITHIN 6'-0" OF LAVATORY, EXISTING RECEPTACLE TO BE REPLACED WITH GFCI TYPE RECEPTACLE.

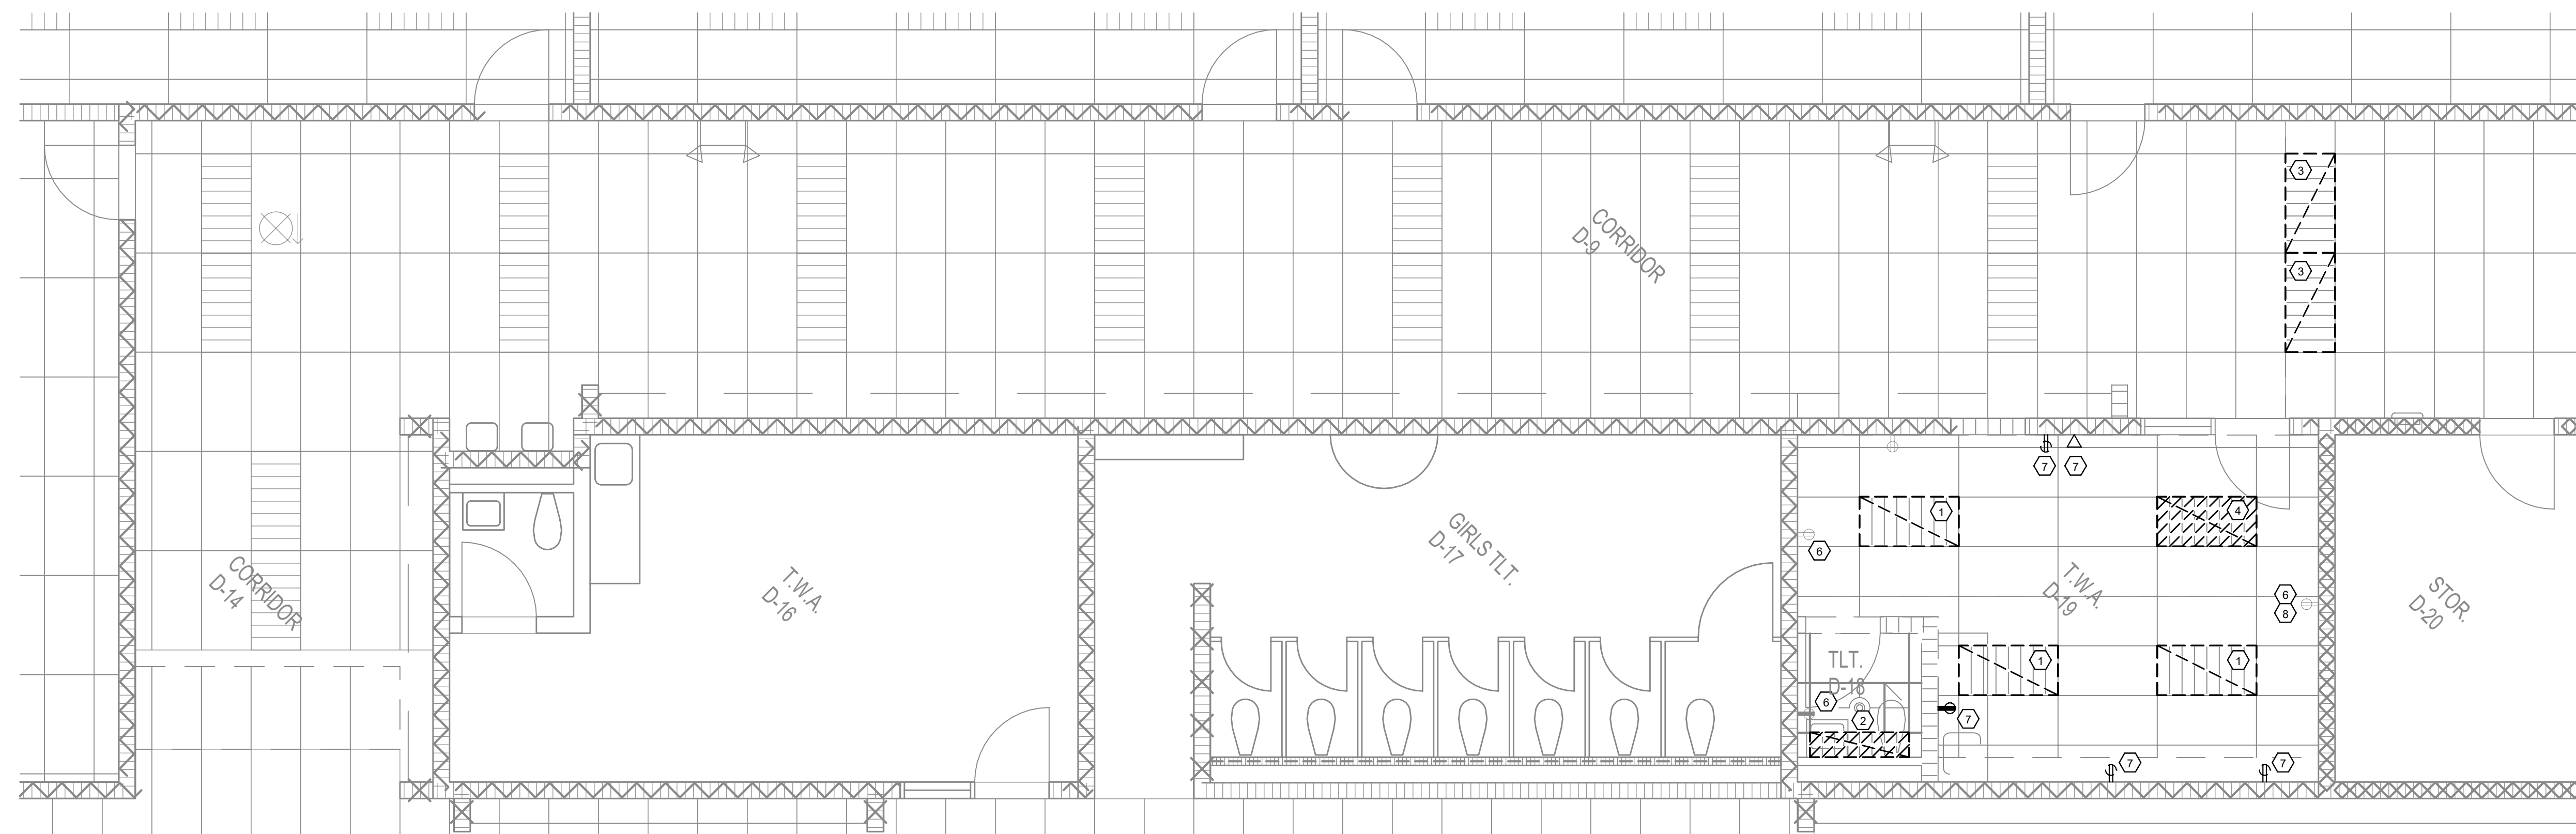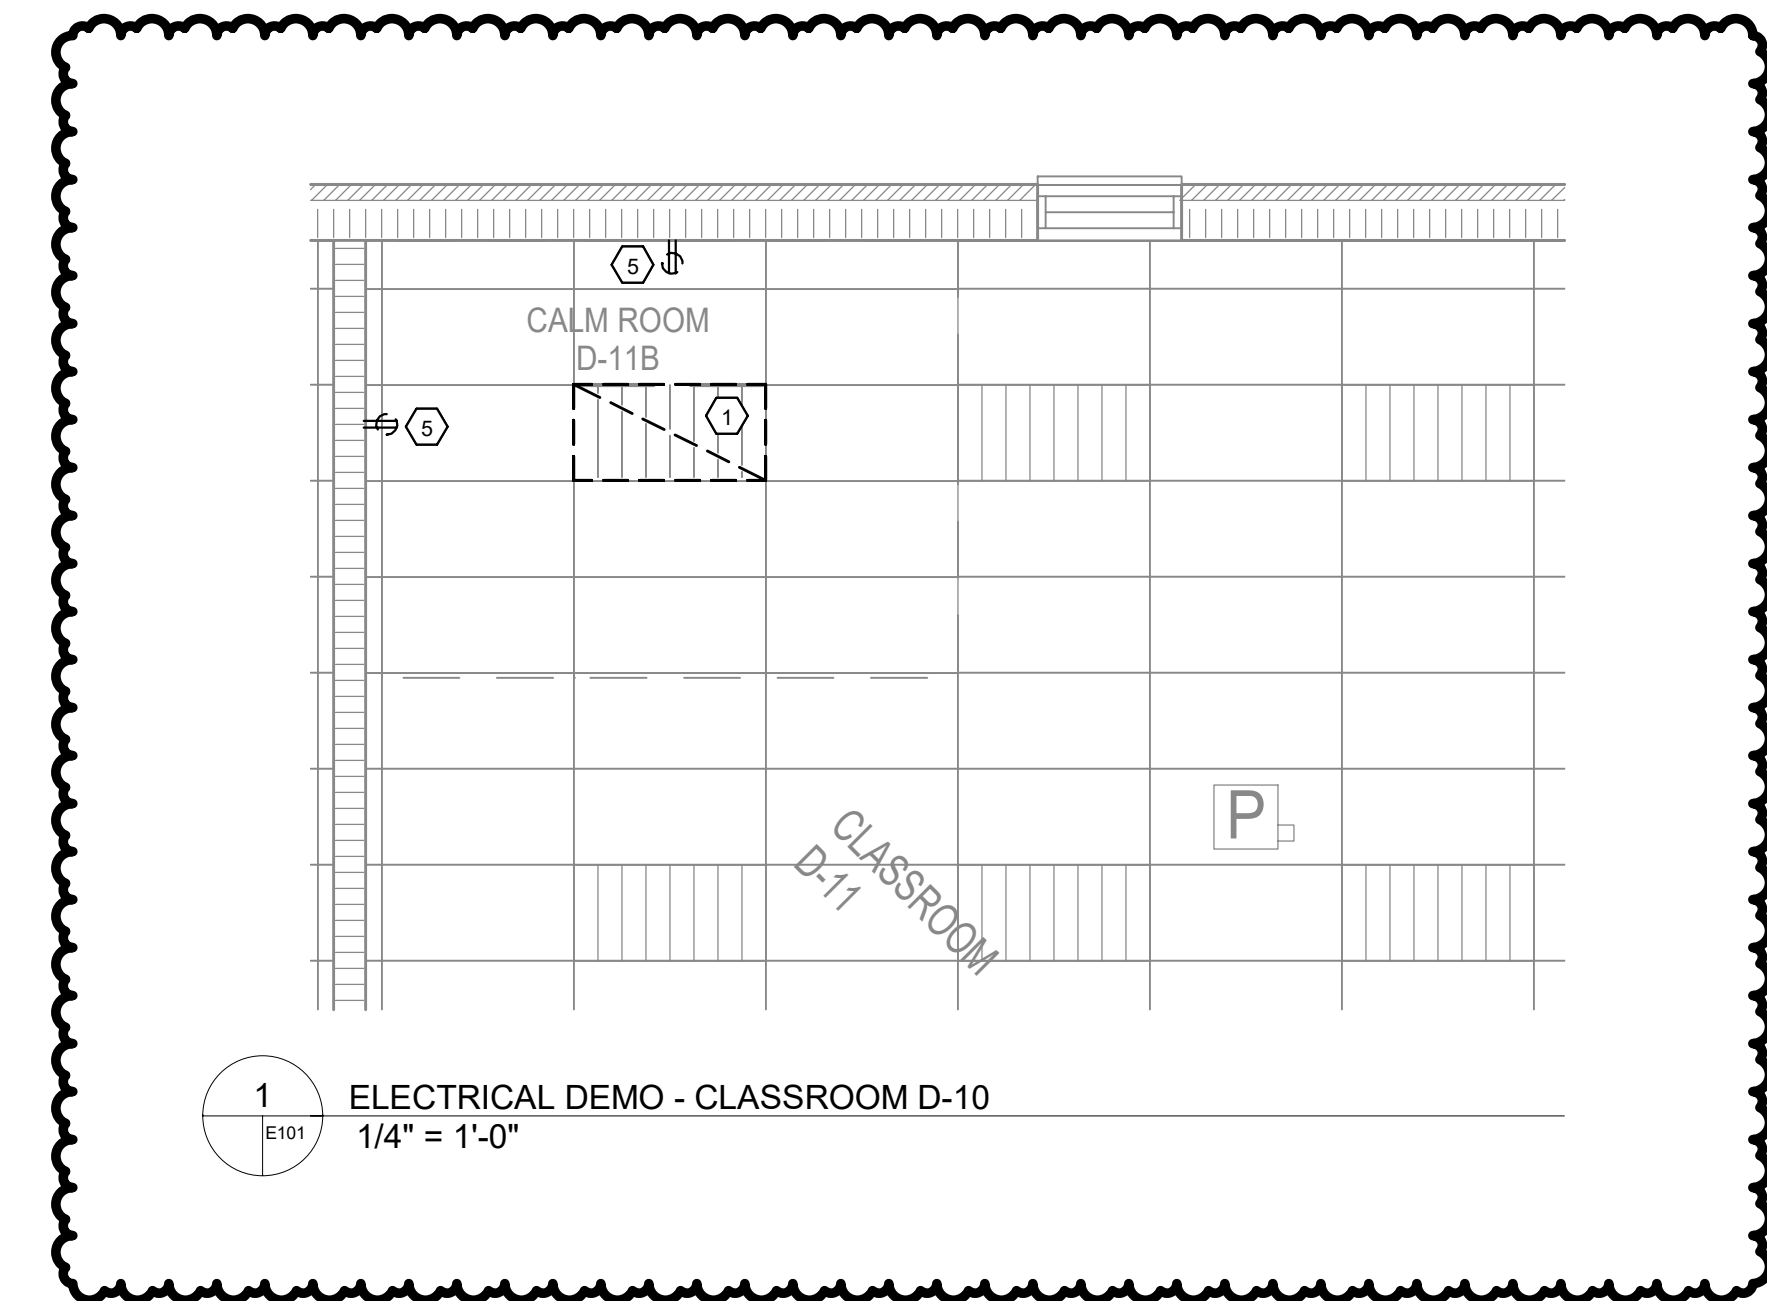


**2**  
 ELECTRICAL DEMO - CORRIDOR D-9, D-14, TLT. D-18, &  
 T.W.A. D-19  
 1/4" = 1'-0"

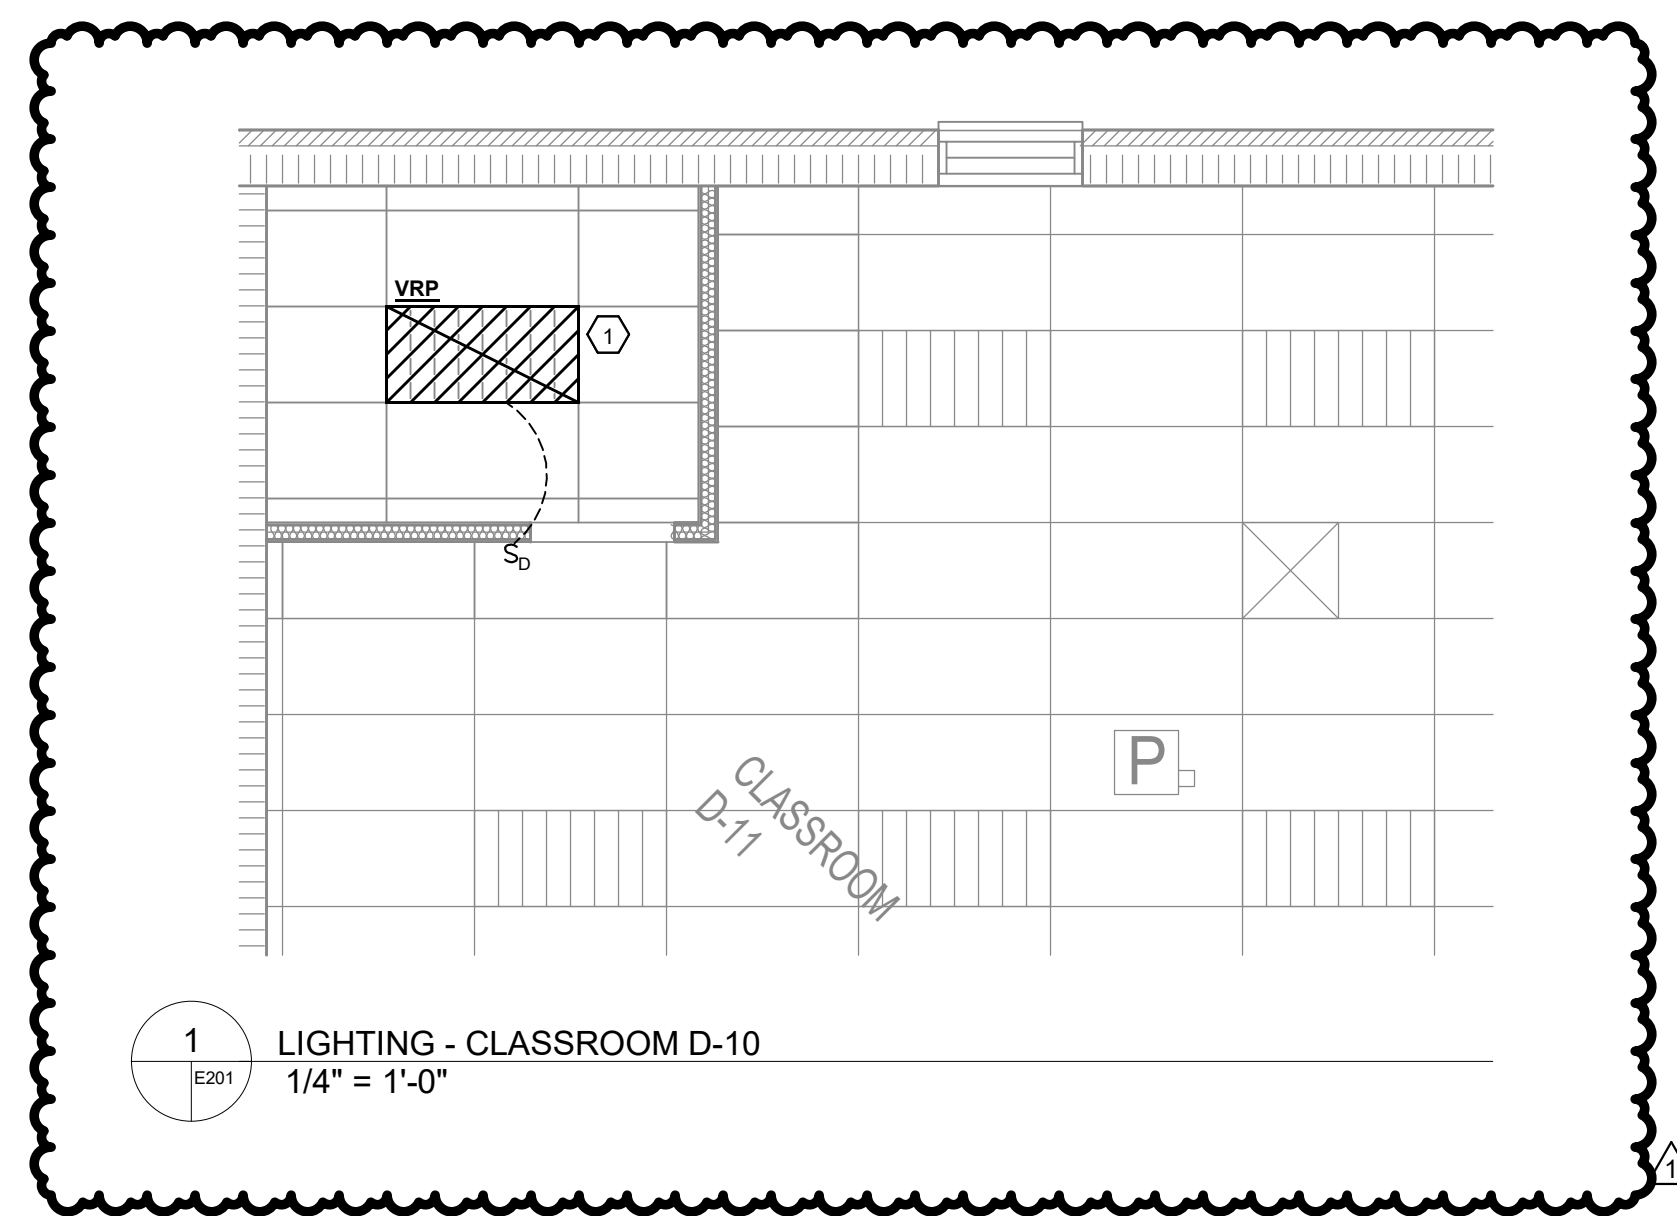


1 LIGHTING - CLASSROOM D-10  
1/4" = 1'-0"

**LIGHTING KEYED NOTES**

1. PROVIDE NEW 2X4 VANDAL RESISTANT LIGHT FIXTURE WITH EMERGENCY POWER CONNECTION AND SWITCH FOR QUIET ROOM. CONNECT TO LOCAL EMERGENCY LIGHTING CIRCUIT, HD-18.
2. EXISTING 2X4 CORRIDOR LIGHT RELOCATED. RECONNECT TO LOCAL LIGHTING CIRCUIT.
3. NEW 2X4 LIGHT WITH EMERGENCY POWER CONNECTION. CONNECT TO LOCAL EMERGENCY LIGHTING CIRCUIT, HD-18, AND PROVIDE NEW SWITCHING.
4. NEW 2X4 LIGHT. CONNECT TO LOCAL LIGHTING CIRCUIT, HD-5, 7.
5. PROVIDE NEW EXIT LIGHTING AND CONNECT TO LOCAL EMERGENCY POWER LIGHTING CIRCUIT, HD-18. MATCH BUILDING STANDARD MODEL, STYLE, AND COLOR.

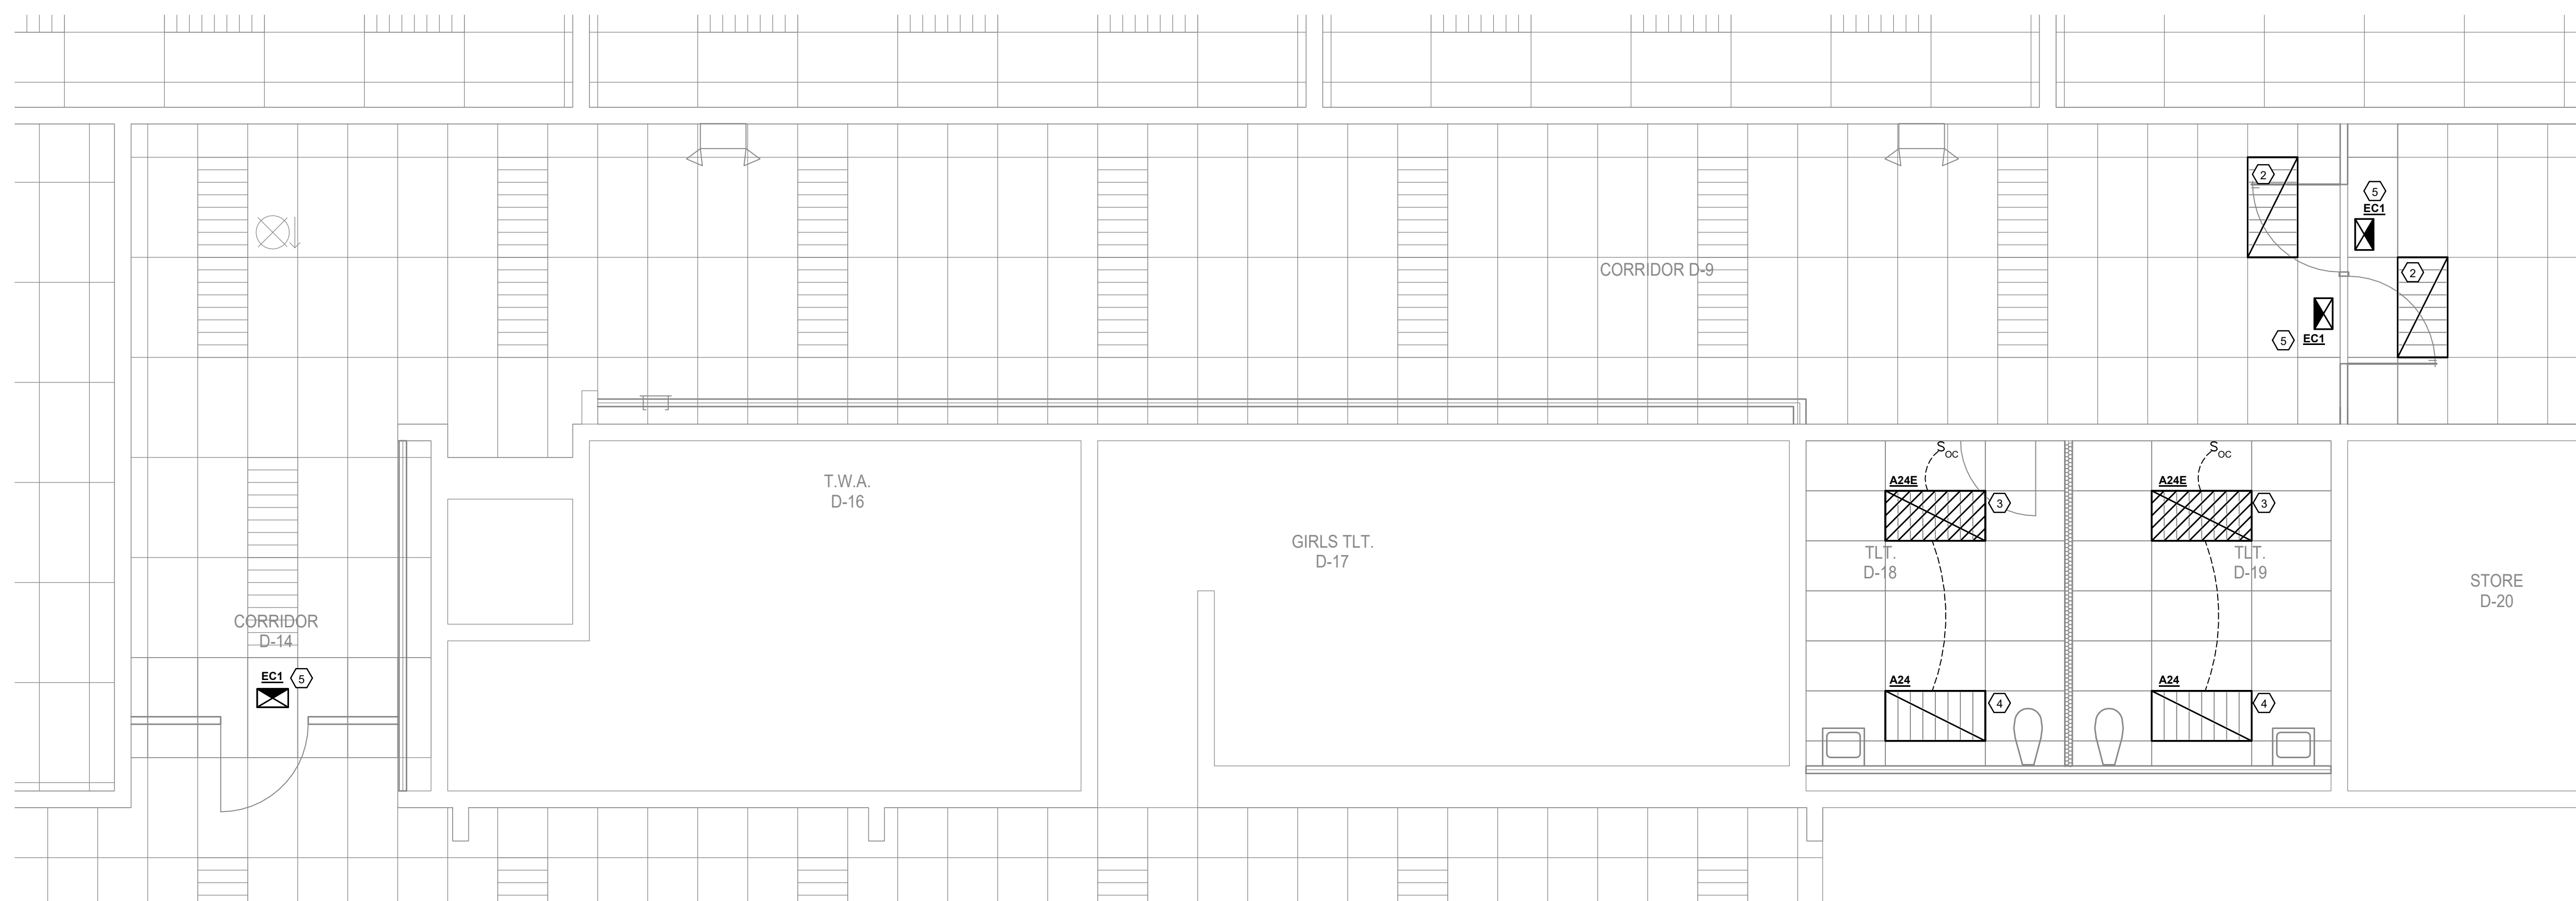


2 LIGHTING - CORRIDOR D-9, D-14, TLT. D-18, & T.W.A. D-19  
1/4" = 1'-0"

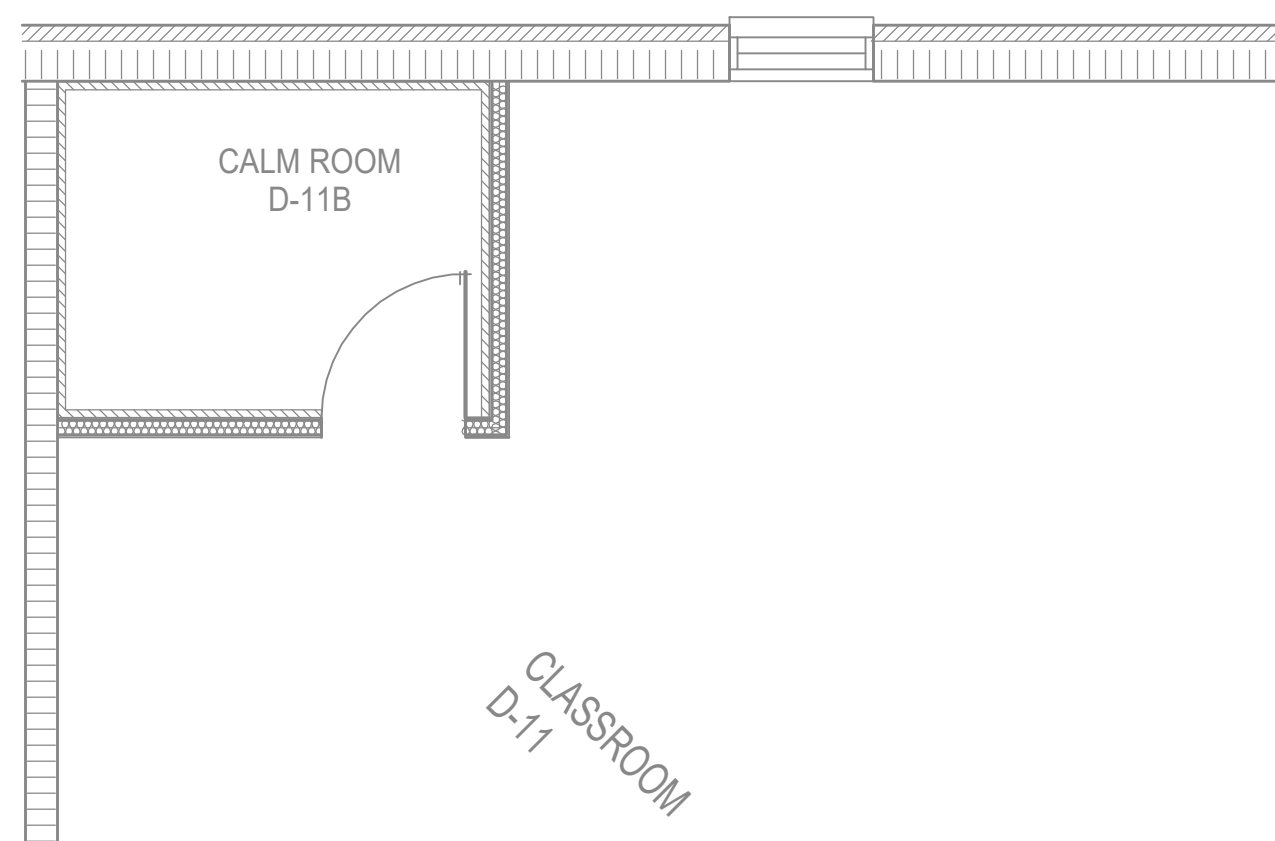

3 POWER & SYSTEMS - CLASSROOM D-10  
1/4" = 1'-0"

**POWER & SYSTEMS KEYED NOTES**

1. PROVIDE NEW GFI RECEPTACLE. REWORK WIRING FOR NEW CONFIGURATION TO CIRCUIT IN PANEL LD.
2. PROVIDE NEW RECEPTACLE AND REWORK WIRING FOR NEW CONFIGURATION TO CIRCUIT IN PANEL LD.
3. PROVIDE NEW WALL MOUNTED FA STROBES FOR TOILETS D-18 & D-19. CONNECT TO EXISTING FA SYSTEM.

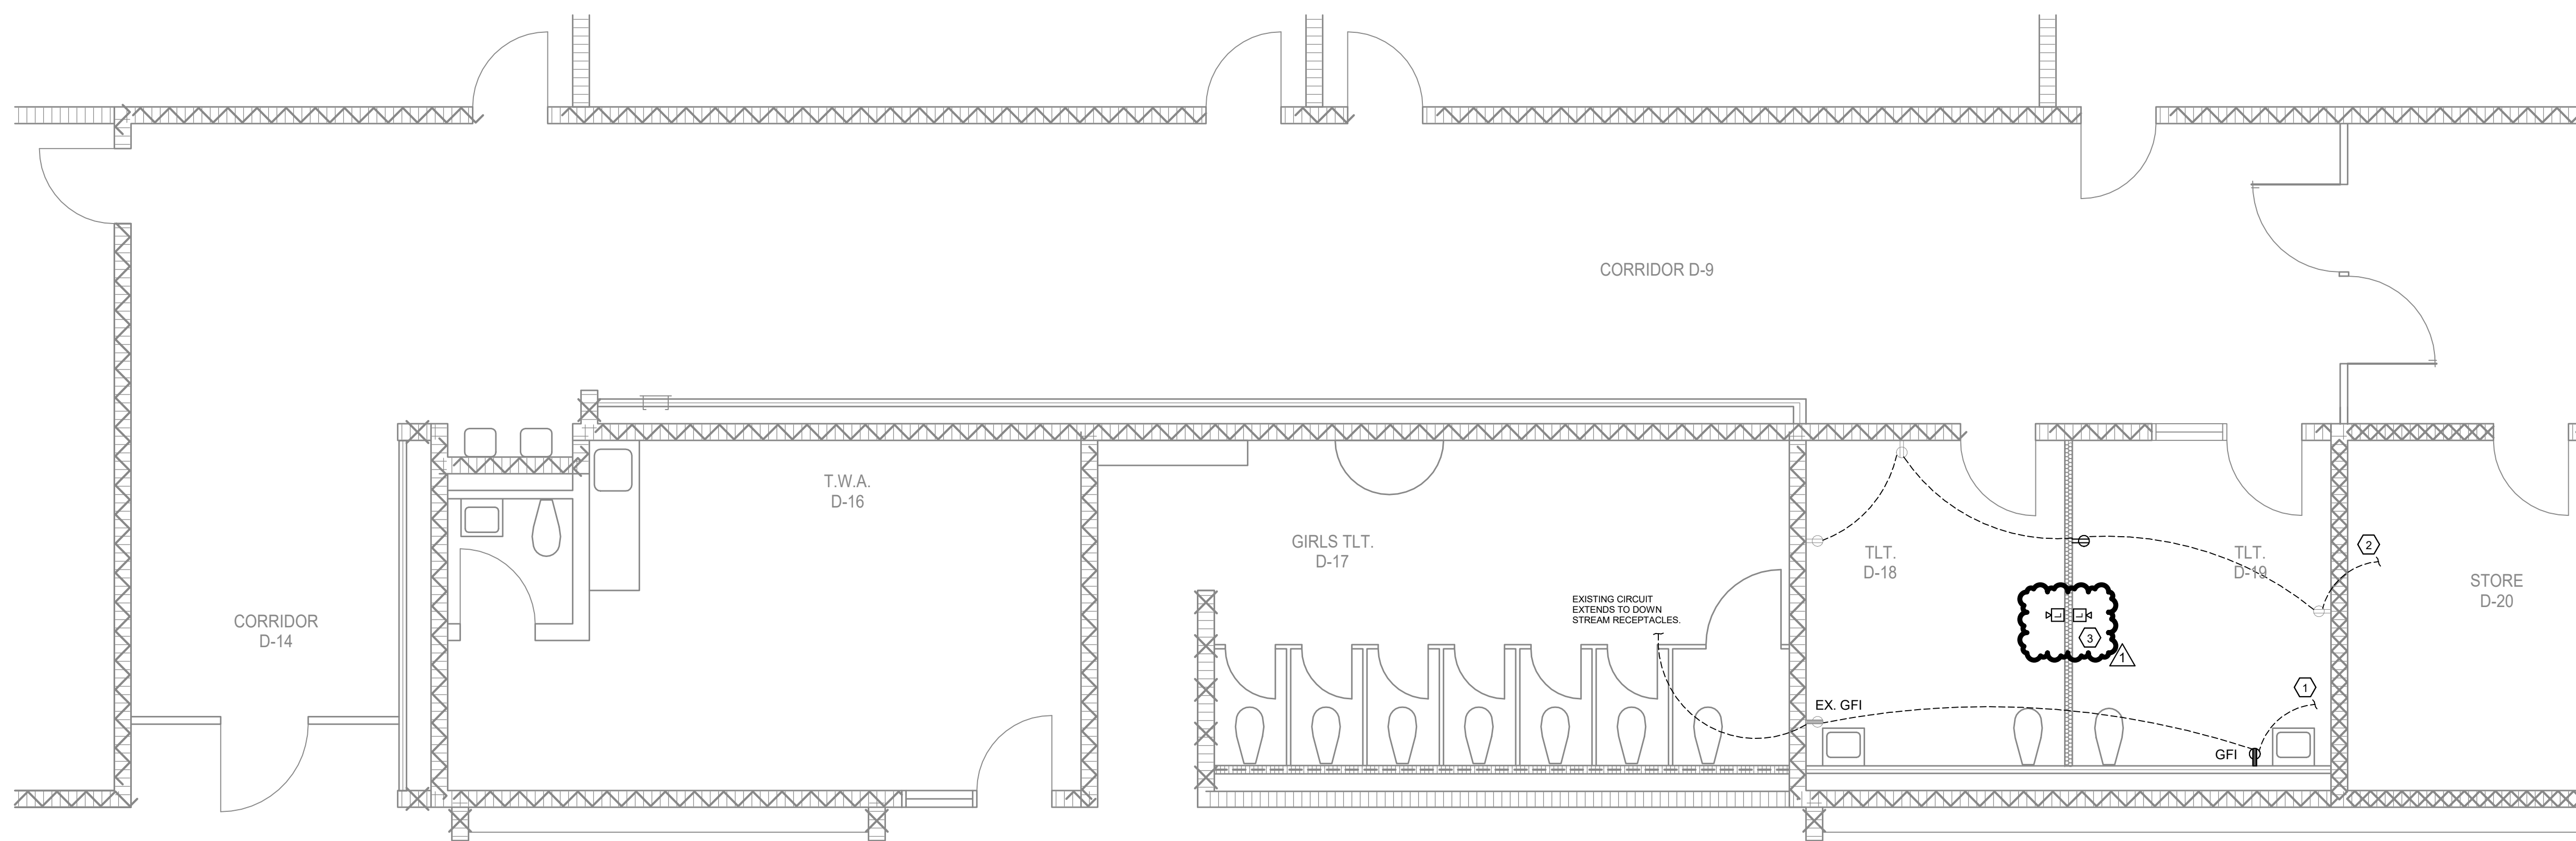

4 POWER & SYSTEMS - CORRIDOR D-9, D-14, TLT. D-18, & T.W.A. D-19  
1/4" = 1'-0"

| REVISION   | DATE     |
|------------|----------|
| Addendum 1 | 5/4/2026 |

NOTES:

THIS DRAWING SHALL NOT BE REPRODUCED, PUBLISHED, OR USED IN ANY WAY WITHOUT THE WRITTEN PERMISSION OF THE ARCHITECT.



PROJECT NO. 2519  
DATE 03-10-26  
DRAWN BY C.S.C.  
CHECKED BY C.S.C.